




CONTRACT DRAWINGS
FOR THE CONSTRUCTION OF

UPGRADE FACILITIES AT
VETERANS MEMORIAL PARK
372 NORTH MAIN STREET
ONEIDA, NEW YORK

REVISED 30% DESIGN SUBMISSION

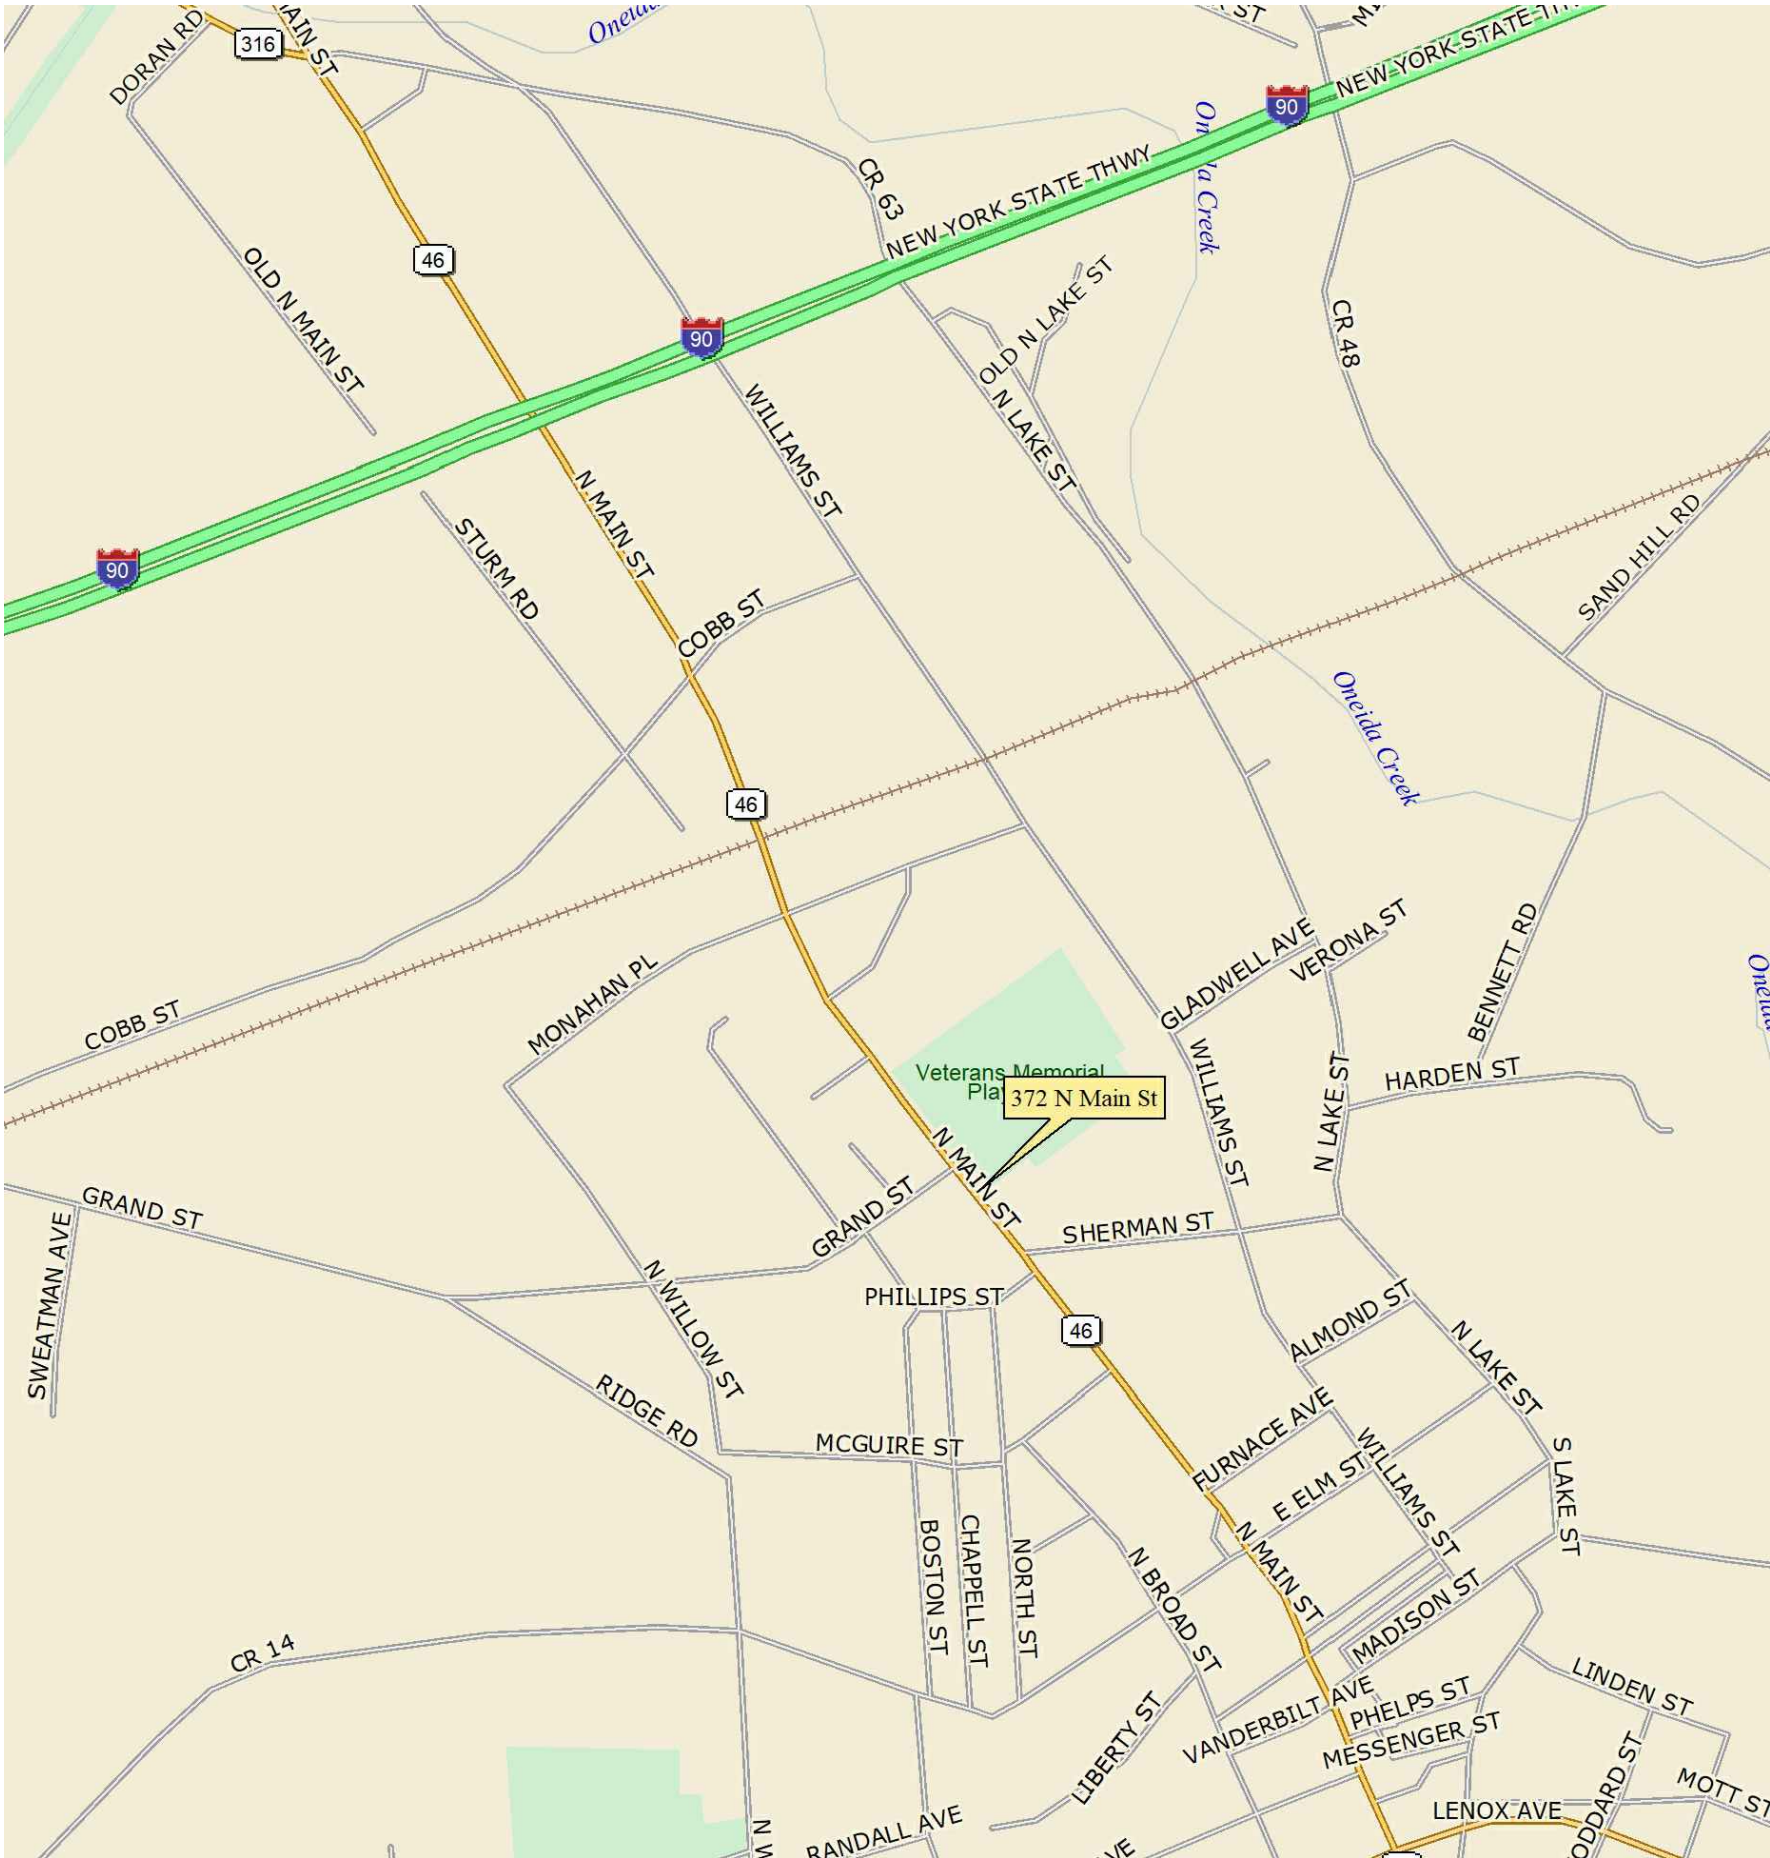

LOCATION MAP



CS100	Overall Site Plan
CS101	Splash Pad Site Plan
CD101	Splash Pad Demolition Plan
CG101	Splash Pad Grading Plan
CU101	Splash Pad Utility Plan
CS102	Pickleball & Basketball Court Site Plan
CD102	Pickleball Court Demolition Plan
CS103	Memorial Circle Site Plan
CD103	Memorial Circle Demolition Plan
CG103	Memorial Circle Grading & Utility Plan
CL103	Memorial Circle Landscape Plan
CS104	Restroom Site Plan
CD104	Restroom Demolition Plan
CG104	Restroom Grading Plan
CS501	Site Details
A-001	General Notes
AD-101	Main Building, Restroom Demolition Plan
AD-102	Secondary Building, Restroom Demolition Plan
A-101	Main Building, Restroom Floor Plan
A-102	Secondary Building, Restroom Floor Plan
A-250	Typical Mounting Heights and Elevations


C&S PROJECT: E42.003.001

APRIL 30, 2026

TO THE BEST OF OUR KNOWLEDGE, INFORMATION AND BELIEF THE PLANS AND SPECIFICATIONS
FOR THIS PROJECT ARE IN COMPLIANCE WITH THE NEW YORK STATE ENERGY CONSERVATION
CONSTRUCTION CODE AND THE BUILDING CODE OF NEW YORK STATE


NO ALTERATION PERMITTED HEREON EXCEPT AS PROVIDED UNDER SECTION 7209
SUBDIVISION 2 OF THE NEW YORK STATE EDUCATION LAW

May 04, 2026 - 4:07pm
F:\ProjectE42 - CITY OF ONEIDA\EA2003001 - Veterans Memorial Park DRI\Design\CADD\Sheet Files\EA2003001_CS100.dwg

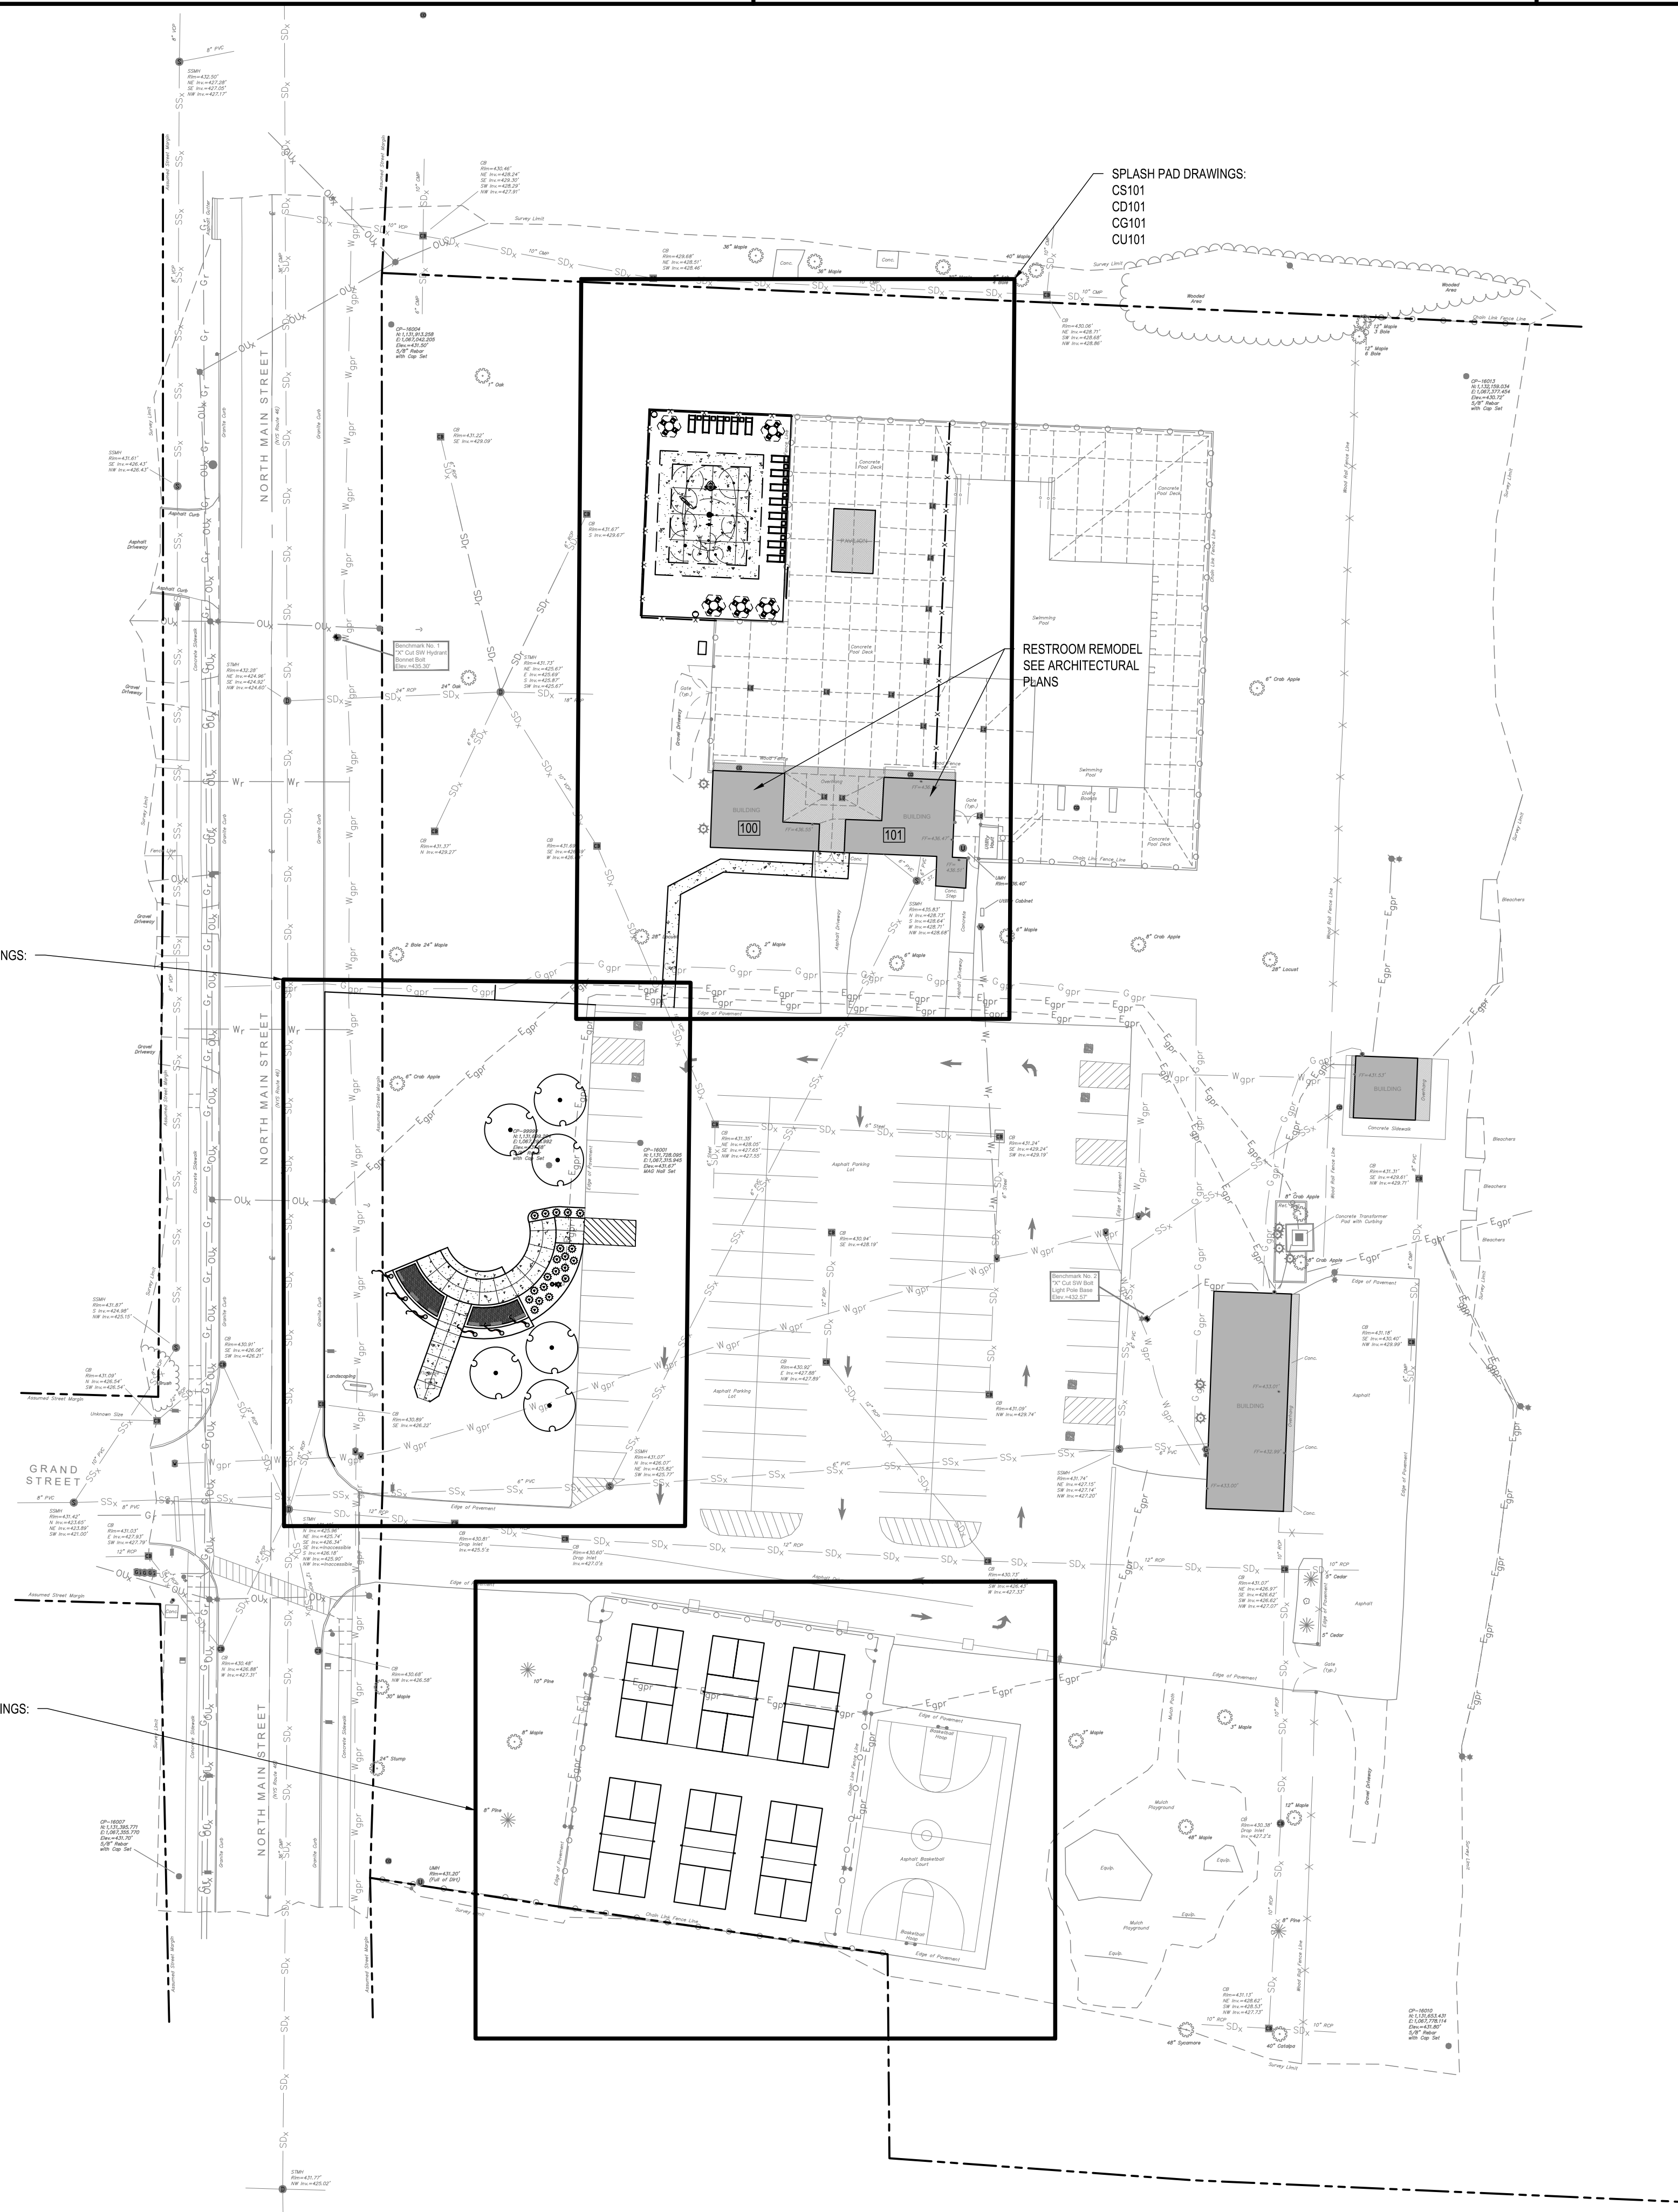

SITE PLAN NOTES

- CONTRACTOR TO VERIFY ALL FIELD CONDITIONS AND UTILITY LOCATIONS PRIOR TO THE START OF CONSTRUCTION. CONTACT THE ENGINEER WITH ANY DISCREPANCIES FOUND IN THE FIELD.
- ALL DIMENSIONS ARE FROM FACE OF CURB UNLESS OTHERWISE NOTED.
- COORDINATE EXACT LOCATION OF SIDEWALKS AT DOORWAYS WITH ARCHITECTURAL PLANS.

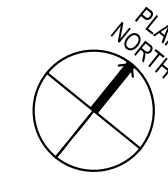

A1 OVERALL SITE PLAN
SCALE: 1"=40'



C&S Engineers, Inc.
141 Elm Street, Suite 100
Buffalo, New York 14203
Phone: 716-847-1630
Fax: 716-847-1454
www.cscos.com

CERTIFICATE OF AUTHORIZATION # 102 365
PRELIMINARY
NOT FOR
CONSTRUCTION

REGISTRATION EXPIRES:

INSERT CLIENT LOGO,
SUBCONSULTANT LOGO, OR
REMOVE THIS AREA AND
RESIZE/CENTER THE
PROJECT IDENTIFICATION
BLOCK

**UPGRADE FACILITIES AT
VETERANS MEMORIAL PARK
372 NORTH MAIN STREET
ONEIDA, NEW YORK**

MARK	DATE	DESCRIPTION
	4/30/26	REVISED PROJECT SCOPE

REVISIONS


PROJECT NO:	E42.003.001
DATE:	JANUARY 6, 2026
DRAWN BY:	S.S.
DESIGNED BY:	V.O.
CHECKED BY:	CHECKED BY

NO ALTERATION PERMITTED HEREON
EXCEPT AS PROVIDED UNDER SECTION
7209 SUBDIVISION 2 OF THE NEW YORK
EDUCATION LAW

**OVERALL
SITE PLAN**

CS100

Jan 05, 2026 - 3:06pm
F:\ProjectE42 - CITY OF ONEIDA\CADD\Sheet Files\E4200001_CD101.dwg

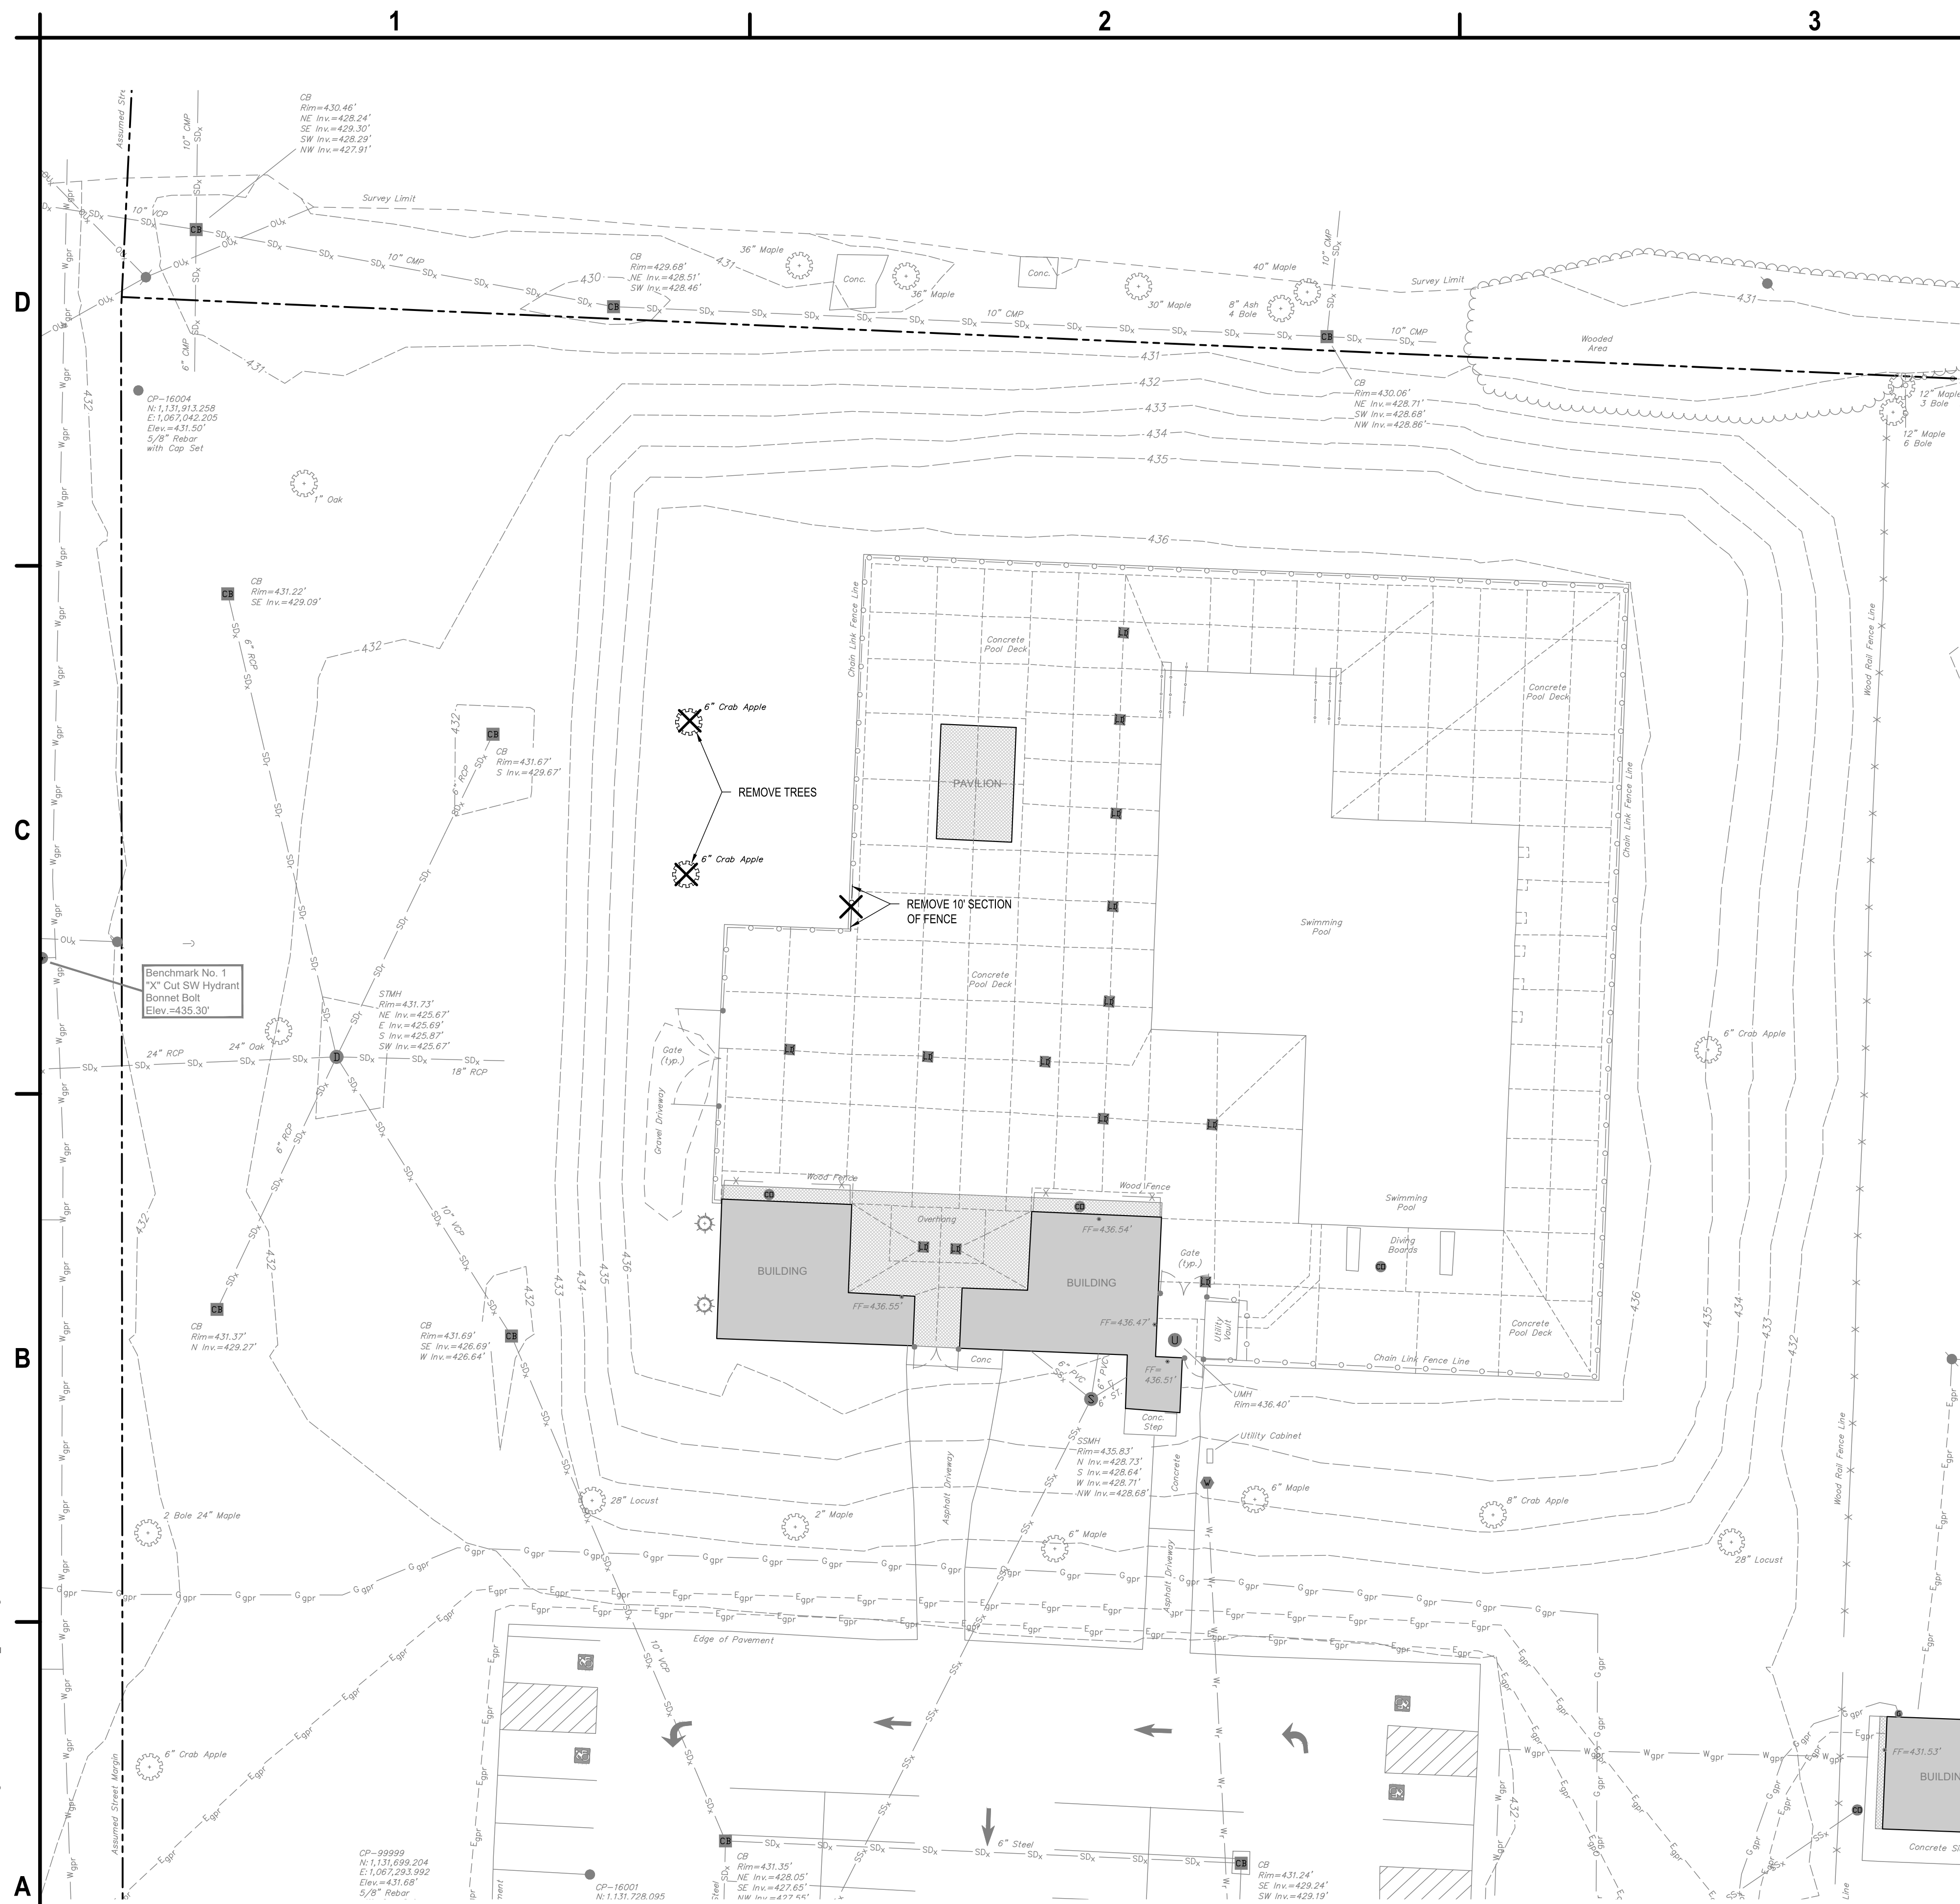

A1 **SPLASH PAD SITE PLAN**
SCALE: 1"=20'

DEMOLITION PLAN NOTES

 
1. CONTRACTOR TO REMOVE & DISPOSE OF ALL ITEMS INDICATED & ANY ITEMS INCIDENTAL TO THE CONSTRUCTION AS REQUIRED.
2. CONTRACTOR SHALL PROTECT/PRESERVE ALL EXISTING ITEMS TO REMAIN, INCLUDING, BUT NOT LIMITED TO BUILDINGS, PAVEMENT, OVERHEAD & BURIED UTILITIES, TREES LANDSCAPING, ETC. DAMAGE TO ITEMS SCHEDULED TO REMAIN SHALL BE REPAIRED OR REPLANTED AT NO ADDITIONAL COST TO THE OWNER.
3. UTILITIES SHOWN ARE APPROXIMATE. CONTRACTOR SHALL HAVE ALL UNDER-GROUND FACILITIES LOCATED AND MARKED PRIOR TO EXCAVATION/DEMOLITION/CONSTRUCTION.
4. DISCONNECT, CAP AND REMOVE/ABANDON EXISTING UTILITIES FOR ALL BUILDINGS TO BE DEMOLISHED, UNLESS NOTED OTHERWISE. ALL UTILITY TERMINATIONS SHALL BE IN ACCORDANCE W/ THE APPLICABLE UTILITY COMPANY REQUIREMENTS.
5. CONTRACTOR SHALL LEGALLY DISPOSE OF ALL MATERIALS/DEBRIS REMOVED FROM THE SITE.
6. THIS PLAN IS PREPARED FROM A SURVEY SHOWING KNOWN SURFACE FEATURES. IT IS INTENDED AS A GUIDE TO THE CONTRACTOR, NOT AS A COMPLETE AND UNIVERSAL DEMOLITION PLAN. SEE THE SITE PLAN. MORE FEATURES (NOT INDICATED) MAY REQUIRE DEMOLITION TO CONSTRUCT THE SITE PLAN. CONTRACTOR MUST VISIT THE SITE TO CONFIRM DEMOLITION EFFORT PRIOR TO BIDDING.
7. REMOVE CONCRETE SIDEWALK AND/OR PAVEMENT TO THE LIMITS INDICATED. SAW CUT CONCRETE TO THE NEAREST EXISTING CONTROL/EXPANSION JOINT.
8. BUILDING DEMOLITION SHALL BE IN ACCORDANCE WITH ALL LOCAL, STATE, AND FEDERAL REQUIREMENTS/REGULATIONS.
9. MAINTAIN STORM SEWER CONTINUITY & POSITIVE DRAINAGE DURING DEMOLITION, REMOVAL & CONSTRUCTION OF STORM SEWERS & INLETS.

DEMOLITION PLAN SHEET KEYNOTES

- ① REMOVE EXISTING CONCRETE PAVEMENT & SUBBASE

DEMOLITION PLAN LEGEND

- CONCRETE/ASPHALT PAVEMENT TO BE REMOVED
- ITEM TO BE REMOVED



C&S Engineers, Inc.
141 Elm Street, Suite 100
Buffalo, New York 14203
Phone: 716-847-1630
Fax: 716-847-1454
www.cscos.com

CERTIFICATE OF AUTHORIZATION # 102 385
PRELIMINARY
NOT FOR
CONSTRUCTION
REGISTRATION EXPIRES:

INSERT CLIENT LOGO,
SUBCONSULTANT LOGO, OR
REMOVE THIS AREA AND
RESIZE/CENTER THE
PROJECT IDENTIFICATION
BLOCK

**UPGRADE FACILITIES AT
VETERANS MEMORIAL PARK
372 NORTH MAIN STREET
ONEIDA, NEW YORK**

MARK	DATE	DESCRIPTION

REVISIONS


PROJECT NO:	E42.003.001
DATE:	JANUARY 6, 2026
DRAWN BY:	DRAWN BY
DESIGNED BY:	DESIGNED BY
CHECKED BY:	CHECKED BY

NO ALTERATION PERMITTED HEREON
EXCEPT AS PROVIDED UNDER SECTION
7209 SUBDIVISION 2 OF THE NEW YORK
EDUCATION LAW

**SPLASH PAD
DEMOLITION PLAN**

CD101

Apr 30, 2026 - 2:10pm
F:\ProjectE42 - CITY OF ONEIDA\EA2003001 - Veterans Memorial Park DRI\Design\CADD\Sheet Files\EA2003001_CS101.dwg

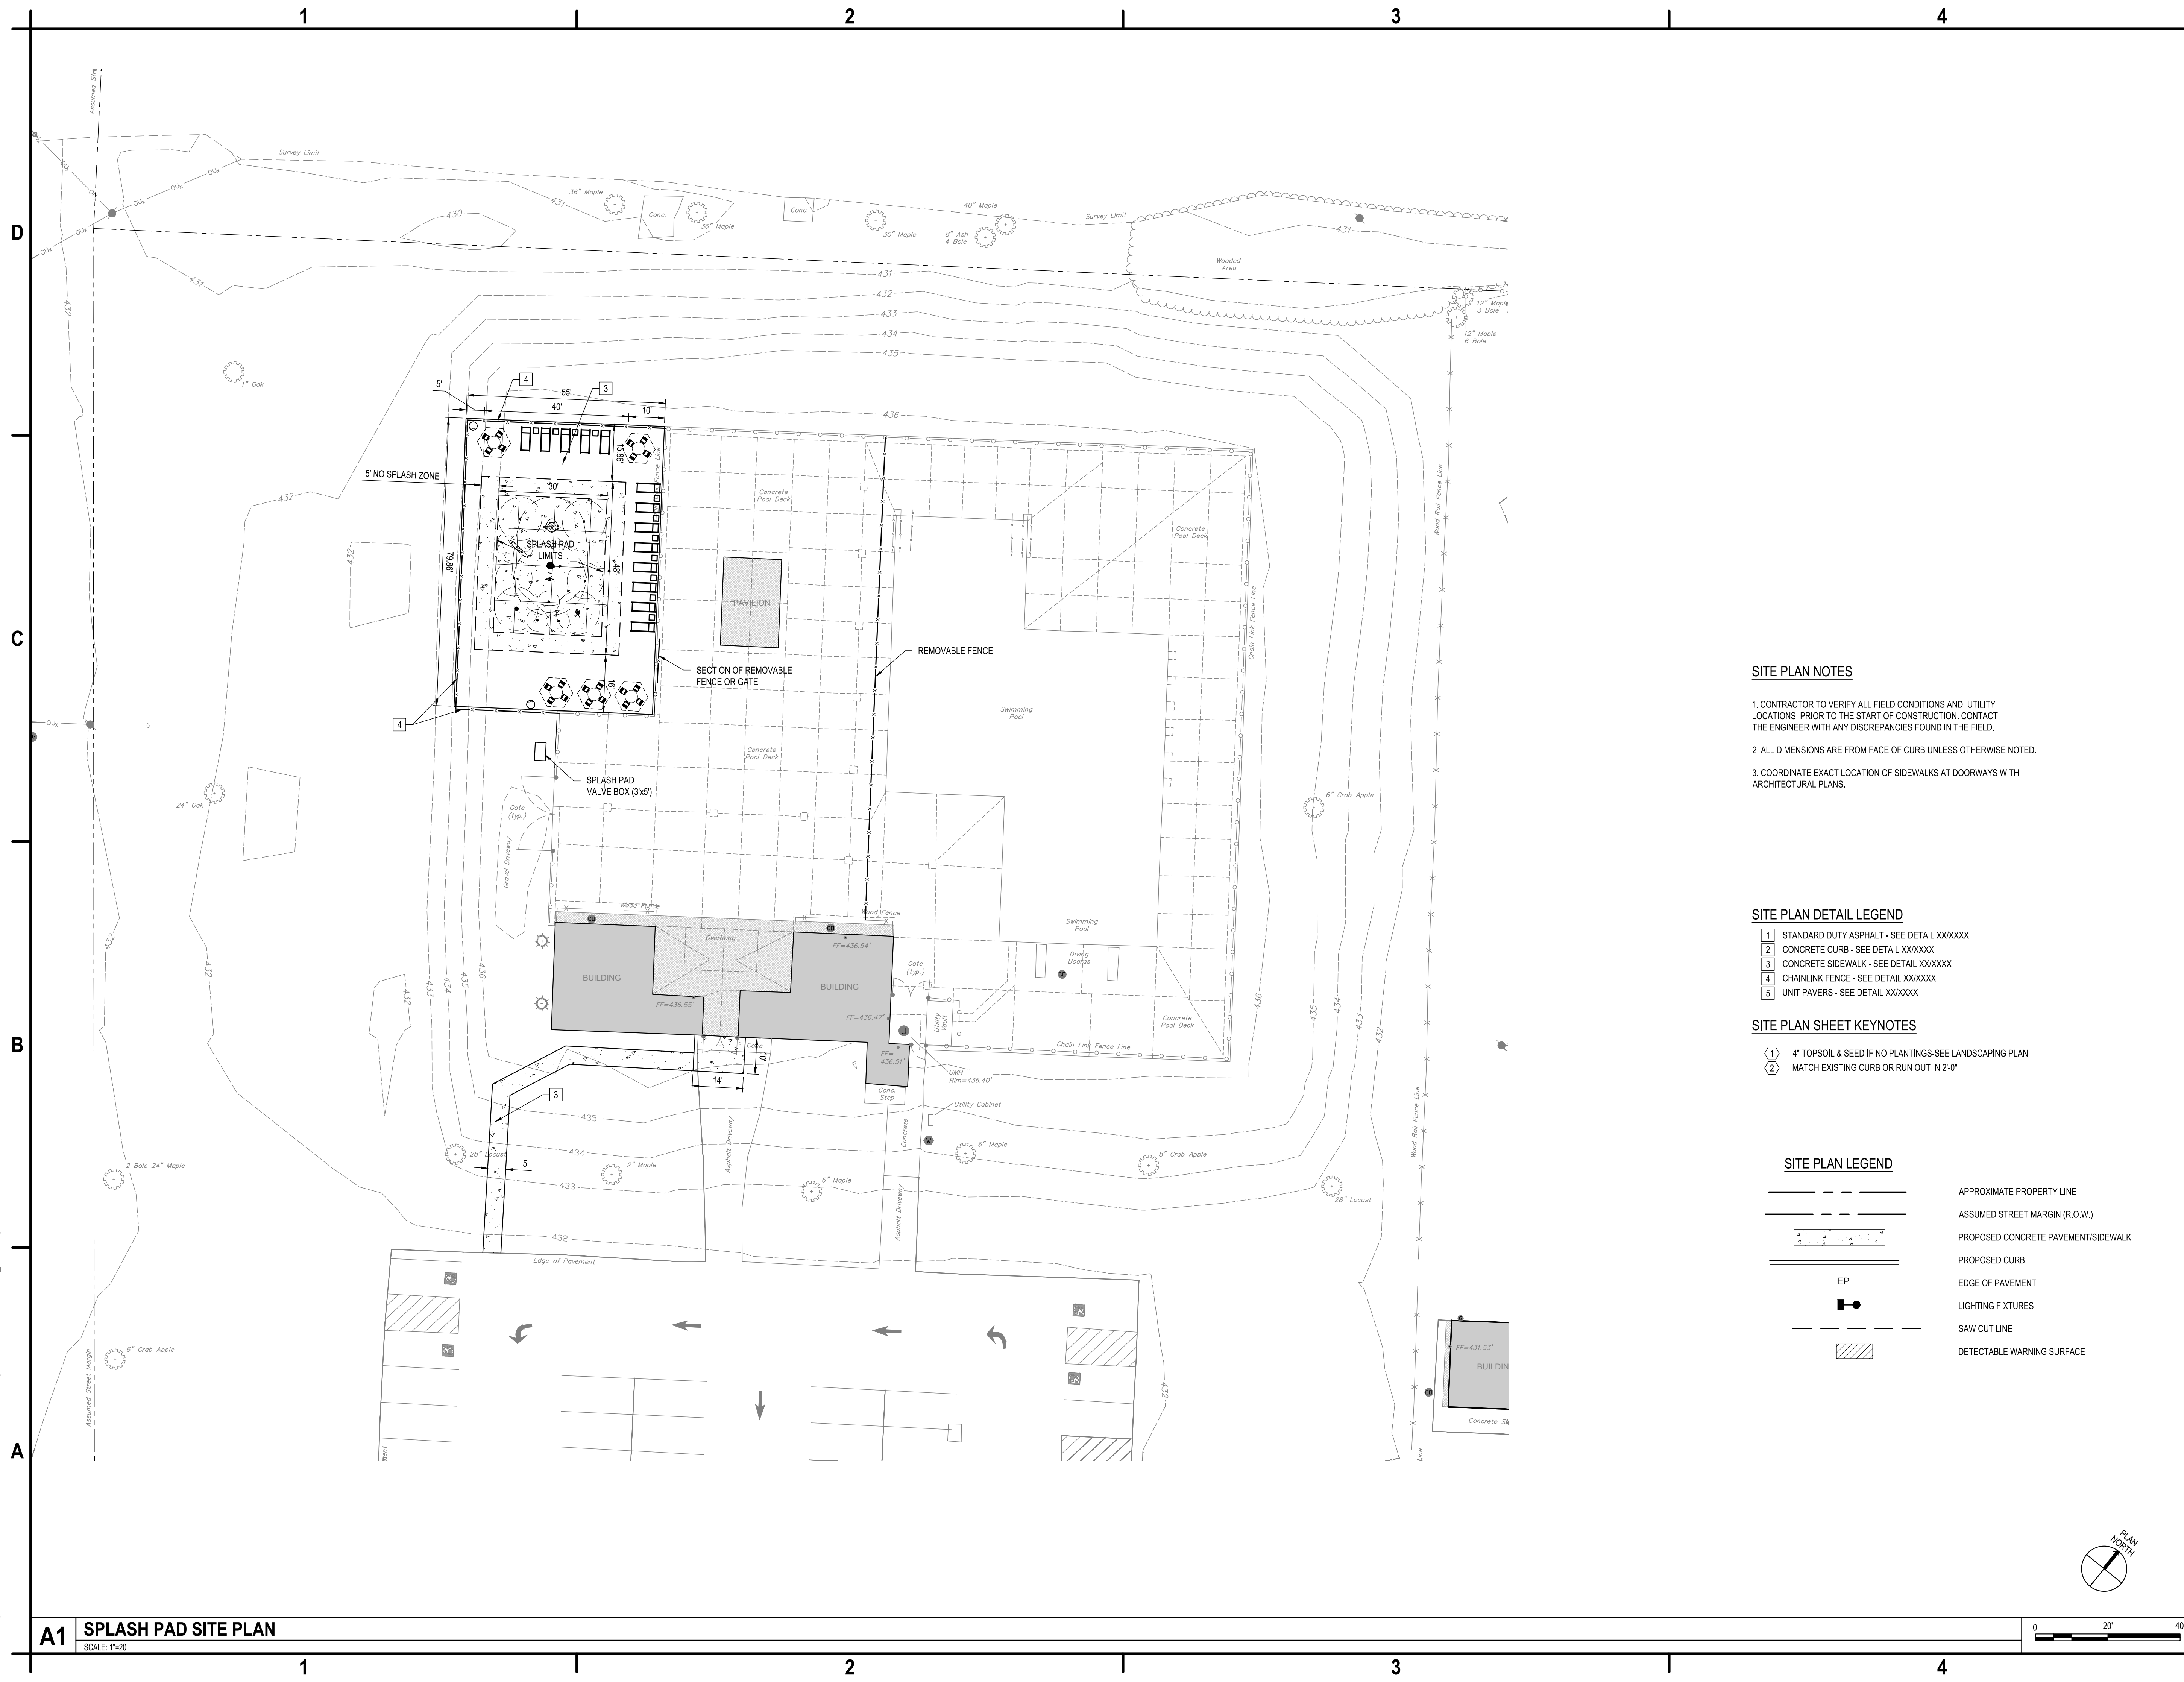

SITE PLAN NOTES

1. CONTRACTOR TO VERIFY ALL FIELD CONDITIONS AND UTILITY LOCATIONS PRIOR TO THE START OF CONSTRUCTION. CONTACT THE ENGINEER WITH ANY DISCREPANCIES FOUND IN THE FIELD.
2. ALL DIMENSIONS ARE FROM FACE OF CURB UNLESS OTHERWISE NOTED.
3. COORDINATE EXACT LOCATION OF SIDEWALKS AT DOORWAYS WITH ARCHITECTURAL PLANS.

SITE PLAN DETAIL LEGEND


- 1 STANDARD DUTY ASPHALT - SEE DETAIL XX/XXXX
- 2 CONCRETE CURB - SEE DETAIL XXXXXX
- 3 CONCRETE SIDEWALK - SEE DETAIL XXXXXXX
- 4 CHAINLINK FENCE - SEE DETAIL XXXXXXX
- 5 UNIT PAVERS - SEE DETAIL XX/XXXX

SITE PLAN SHEET KEYNOTES

- 1 4" TOPSOIL & SEED IF NO PLANTINGS-SEE LANDSCAPING PLAN
- 2 MATCH EXISTING CURB OR RUN OUT IN 2'-0"

SITE PLAN LEGEND

- | | |
|-----|-------------------------------------|
| --- | APPROXIMATE PROPERTY LINE |
| --- | ASSUMED STREET MARGIN (R.O.W.) |
| --- | PROPOSED CONCRETE PAVEMENT/SIDEWALK |
| --- | PROPOSED CURB |
| --- | EDGE OF PAVEMENT |
| --- | LIGHTING FIXTURES |
| --- | SAW CUT LINE |
| --- | DETECTABLE WARNING SURFACE |

 

A1 SPLASH PAD SITE PLAN
SCALE: 1"=20'



C&S Engineers, Inc.
141 Elm Street, Suite 100
Buffalo, New York 14203
Phone: 716-847-1630
Fax: 716-847-1454
www.cscos.com

CERTIFICATE OF AUTHORIZATION # 102 385
PRELIMINARY
NOT FOR
CONSTRUCTION
REGISTRATION EXPIRES:

INSERT CLIENT LOGO,
SUBCONSULTANT LOGO, OR
REMOVE THIS AREA AND
RESIZE/CENTER THE
PROJECT IDENTIFICATION
BLOCK

UPGRADE FACILITIES AT
VETERANS MEMORIAL PARK
372 NORTH MAIN STREET
ONEIDA, NEW YORK

MARK	DATE	DESCRIPTION
	4/30/26	REVISED PROJECT SCOPE

REVISIONS	
PROJECT NO:	E42.003.001
DATE:	JANUARY 6, 2026
DRAWN BY:	S.S.
DESIGNED BY:	V.O.
CHECKED BY:	CHECKED BY

NO ALTERATION PERMITTED HEREON
EXCEPT AS PROVIDED UNDER SECTION
7209 SUBDIVISION 2 OF THE NEW YORK
EDUCATION LAW



SPLASH PAD
SITE PLAN

CS101

Apr 30, 2026 - 2:10pm
F:\ProjectE42 - City of Oneida\CAD\Sheet\Files\E4200001_CG101.dwg



GRADING PLAN LEGEND		
	PROPOSED CURB	
	EXISTING POINT ELEVATION	
	PROPOSED POINT ELEVATION	
	EXISTING CONTOUR	
	PROPOSED CONTOUR	
	TOP OF CURB	
	BOTTOM OF CURB	
	HIGH POINT	
	FLOW DIRECTION	

 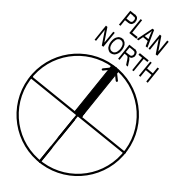

A1 **SPLASH PAD GRADING PLAN**
SCALE: 1"=20'



C&S Engineers, Inc.
141 Elm Street, Suite 100
Buffalo, New York 14203
Phone: 716-847-1630
Fax: 716-847-1454
www.cscos.com

CERTIFICATE OF AUTHORIZATION # 004 385
PRELIMINARY
NOT FOR
CONSTRUCTION
REGISTRATION EXPIRES:

INSERT CLIENT LOGO,
SUBCONSULTANT LOGO, OR
REMOVE THIS AREA AND
RESIZE/CENTER THE
PROJECT IDENTIFICATION
BLOCK

**UPGRADE FACILITIES AT
VETERANS MEMORIAL PARK
372 NORTH MAIN STREET
ONEIDA, NEW YORK**

MARK	DATE	DESCRIPTION
REVISIONS		
PROJECT NO: E42.003.001		
DATE: JANUARY 6, 2026		
DRAWN BY: DRAWN BY		
DESIGNED BY: DESIGNED BY		
CHECKED BY: CHECKED BY		
NO ALTERATION PERMITTED HEREON EXCEPT AS PROVIDED UNDER SECTION 7209 SUBDIVISION 2 OF THE NEW YORK EDUCATION LAW		

**SPLASH PAD
GRADING PLAN**

CG101



May 04, 2026 - 3:54pm
F:\ProjectE42 - CITY OF ONEIDA\00000001 - Veterans Memorial Park DRI\Design\CADD\Sheet Files\E4200001_CU101.dwg



A1 **SPLASH PAD UTILITY PLAN**
SCALE: 1"=20'

UTILITY PLAN LEGEND

- | | | |
|------|-----|-------------------------|
| SSx | SSx | EXISTING SANITARY SEWER |
| SDx | SDx | EXISTING STORM SEWER |
| Wgr | Wgr | EXISTING WATER MAIN |
| Okx | Okx | EXISTING ELECTRIC |
| Ggr | Ggr | EXISTING GAS |
| SA | | PROPOSED SANITARY SEWER |
| ST | | PROPOSED STORM SEWER |
| W | | PROPOSED WATER MAIN |
| E | | PROPOSED ELECTRIC |
| G | | PROPOSED GAS |
| YD | | PROPOSED HYDRANT |
| C.O. | | PROPOSED MANHOLE |
| | | PROPOSED CATCH BASIN |
| | | PROPOSED YARD DRAIN |
| | | PROPOSED CLEAN OUT |
| | | PROPOSED LIGHT STANDARD |

 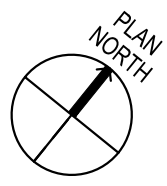

C&S Engineers, Inc.
141 Elm Street, Suite 100
Buffalo, New York 14203
Phone: 716-847-1630
Fax: 716-847-1454
www.cscos.com

CERTIFICATE OF AUTHORIZATION # 002 385
PRELIMINARY
NOT FOR
CONSTRUCTION
REGISTRATION EXPIRES:

INSERT CLIENT LOGO,
SUBCONSULTANT LOGO, OR
REMOVE THIS AREA AND
RESIZE/CENTER THE
PROJECT IDENTIFICATION
BLOCK


**UPGRADE FACILITIES AT
VETERANS MEMORIAL PARK
372 NORTH MAIN STREET
ONEIDA, NEW YORK**

	4/30/26	REVISED PROJECT SCOPE
MARK	DATE	DESCRIPTION
REVISIONS		
PROJECT NO:	E42.003.001	
DATE:	JANUARY 6, 2026	
DRAWN BY:	S.S.	
DESIGNED BY:	V.O.	
CHECKED BY:	CHECKED BY	
NO ALTERATION PERMITTED HEREON EXCEPT AS PROVIDED UNDER SECTION 7209 SUBDIVISION 2 OF THE NEW YORK EDUCATION LAW		

**SPLASH PAD
UTILITY PLAN**

CU101

Apr 30, 2026 - 2:10pm
F:\ProjectE42 - CITY OF ONEIDA\EA2\003001 - Veterans Memorial Park DRI\Design\CADD\Sheet Files\EA2\003001_CD102.dwg

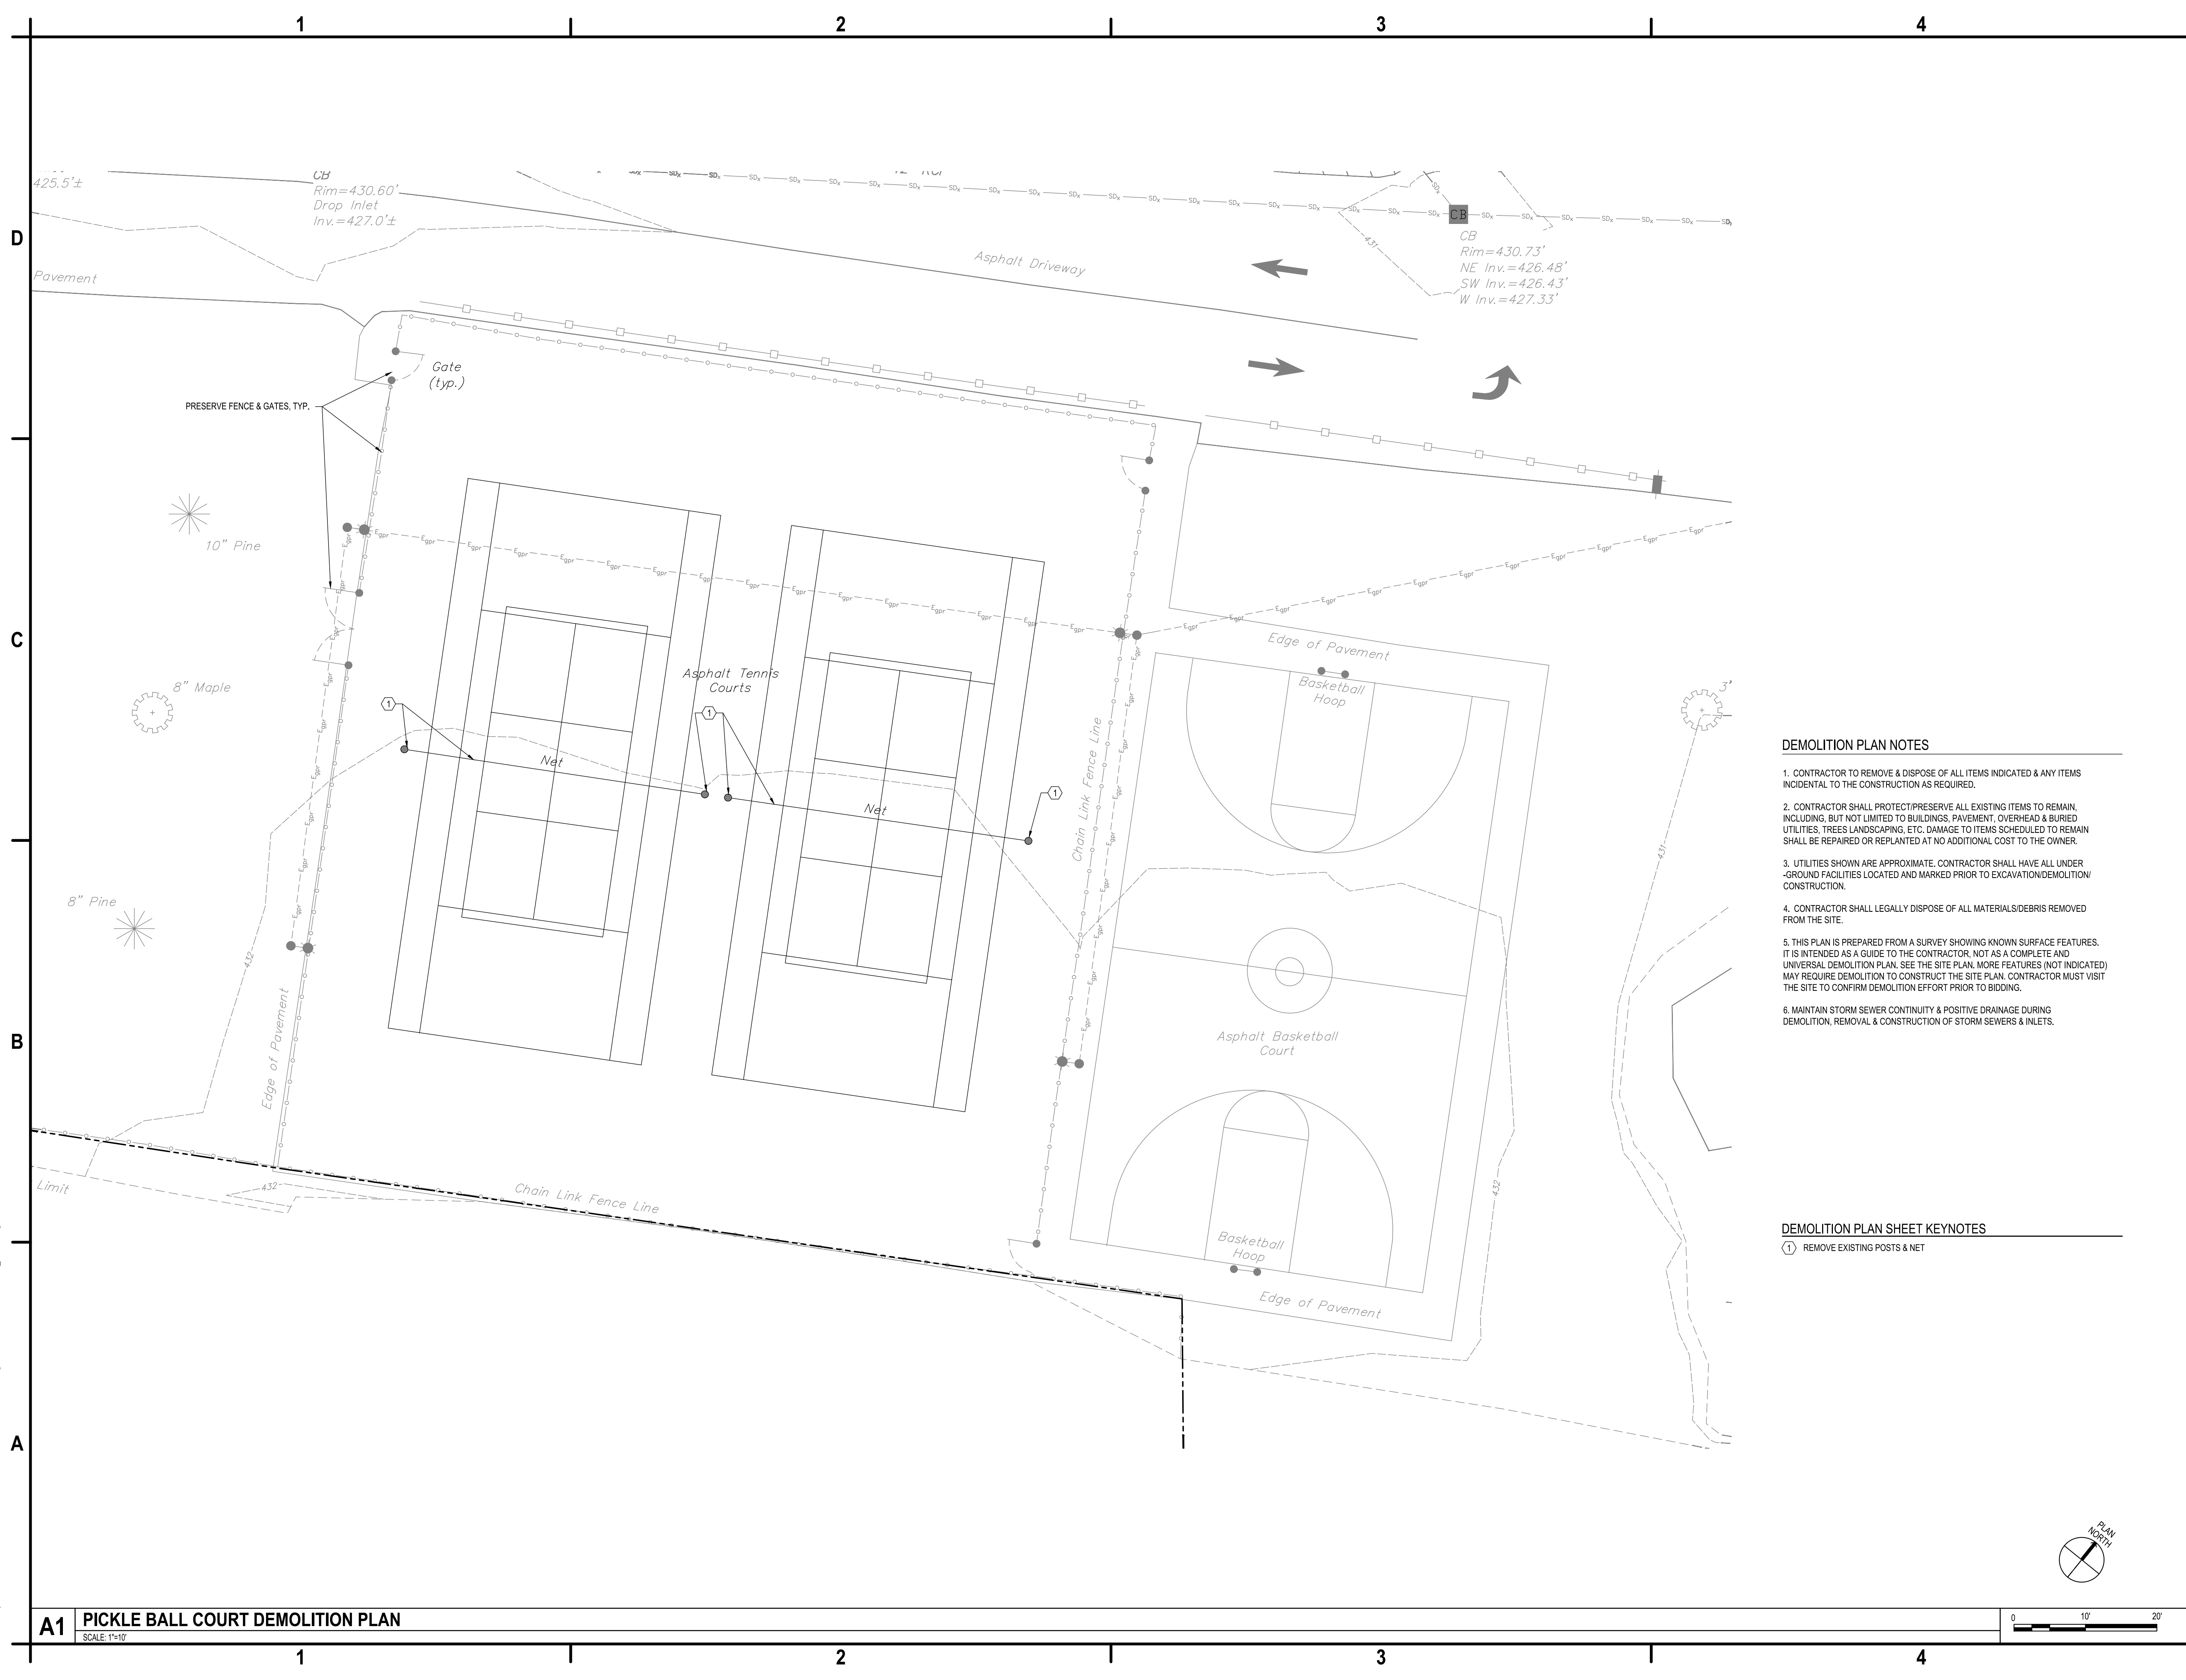

- DEMOLITION PLAN NOTES**
1. CONTRACTOR TO REMOVE & DISPOSE OF ALL ITEMS INDICATED & ANY ITEMS INCIDENTAL TO THE CONSTRUCTION AS REQUIRED.
 2. CONTRACTOR SHALL PROTECT/PRESERVE ALL EXISTING ITEMS TO REMAIN, INCLUDING, BUT NOT LIMITED TO BUILDINGS, PAVEMENT, OVERHEAD & BURIED UTILITIES, TREES LANDSCAPING, ETC. DAMAGE TO ITEMS SCHEDULED TO REMAIN SHALL BE REPAIRED OR REPLANTED AT NO ADDITIONAL COST TO THE OWNER.
 3. UTILITIES SHOWN ARE APPROXIMATE. CONTRACTOR SHALL HAVE ALL UNDER-GROUND FACILITIES LOCATED AND MARKED PRIOR TO EXCAVATION/DEMOLITION/CONSTRUCTION.
 4. CONTRACTOR SHALL LEGALLY DISPOSE OF ALL MATERIALS/DEBRIS REMOVED FROM THE SITE.
 5. THIS PLAN IS PREPARED FROM A SURVEY SHOWING KNOWN SURFACE FEATURES. IT IS INTENDED AS A GUIDE TO THE CONTRACTOR, NOT AS A COMPLETE AND UNIVERSAL DEMOLITION PLAN. SEE THE SITE PLAN. MORE FEATURES (NOT INDICATED) MAY REQUIRE DEMOLITION TO CONSTRUCT THE SITE PLAN. CONTRACTOR MUST VISIT THE SITE TO CONFIRM DEMOLITION EFFORT PRIOR TO BIDDING.
 6. MAINTAIN STORM SEWER CONTINUITY & POSITIVE DRAINAGE DURING DEMOLITION, REMOVAL & CONSTRUCTION OF STORM SEWERS & INLETS.

- DEMOLITION PLAN SHEET KEYNOTES**
- (1) REMOVE EXISTING POSTS & NET

A1 PICKLE BALL COURT DEMOLITION PLAN
SCALE: 1"=10'



C&S Engineers, Inc.
141 Elm Street, Suite 100
Buffalo, New York 14203
Phone: 716-847-1630
Fax: 716-847-1454
www.cscos.com

CERTIFICATE OF AUTHORIZATION # 1024385
PRELIMINARY
NOT FOR
CONSTRUCTION
REGISTRATION EXPIRES:

INSERT CLIENT LOGO,
SUBCONSULTANT LOGO, OR
REMOVE THIS AREA AND
RESIZE/CENTER THE
PROJECT IDENTIFICATION
BLOCK

**UPGRADE FACILITIES AT
VETERANS MEMORIAL PARK
372 NORTH MAIN STREET
ONEIDA, NEW YORK**


MARK	DATE	DESCRIPTION
	4/30/26	REVISED PROJECT SCOPE

REVISIONS	
PROJECT NO:	E42.003.001
DATE:	JANUARY 6, 2026
DRAWN BY:	S.S.
DESIGNED BY:	V.O.
CHECKED BY:	CHECKED BY
NO ALTERATION PERMITTED HEREON EXCEPT AS PROVIDED UNDER SECTION 7209 SUBDIVISION 2 OF THE NEW YORK EDUCATION LAW	

**PICKLEBALL COURT
DEMOLITION PLAN**

CD102



Apr 30, 2026 - 2:10pm
F:\ProjectE42 - CITY OF ONEIDA\EA2003001 - Veterans Memorial Park DRI\Design\CADD\Sheet Files\EA2003001_CS102.dwg

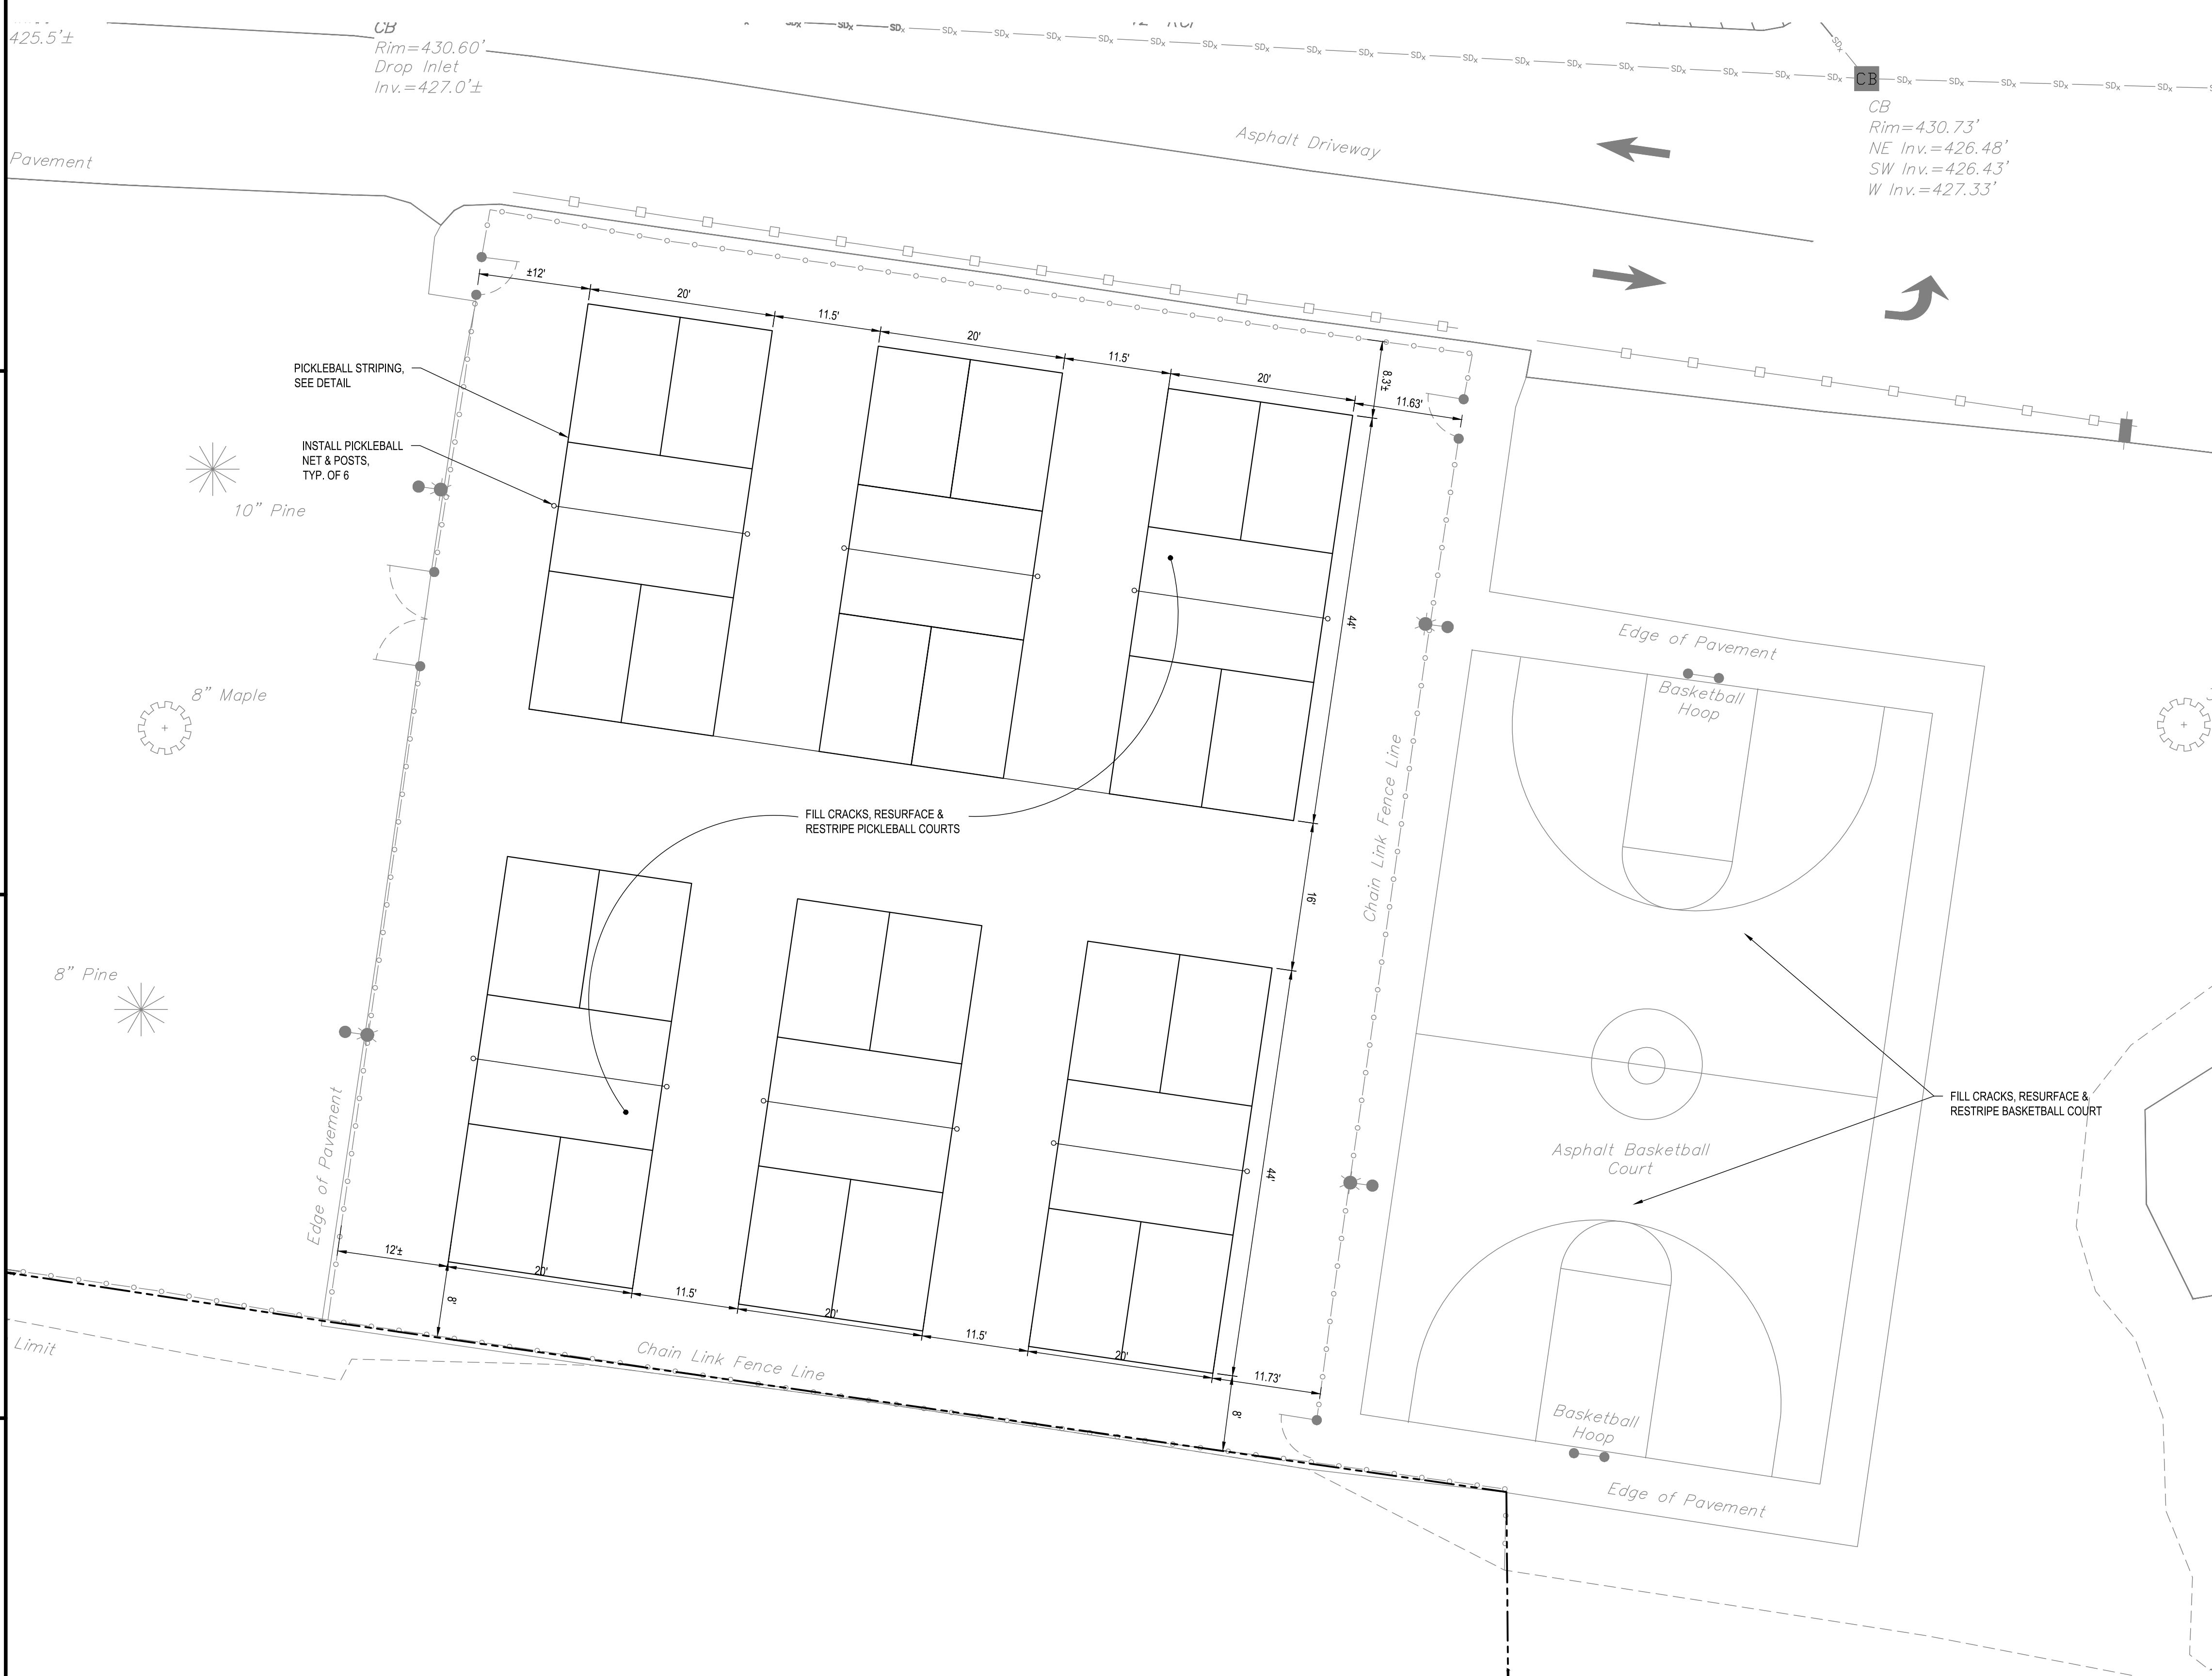

- SITE PLAN NOTES**
1. CONTRACTOR TO VERIFY ALL FIELD CONDITIONS AND UTILITY LOCATIONS PRIOR TO THE START OF CONSTRUCTION. CONTACT THE ENGINEER WITH ANY DISCREPANCIES FOUND IN THE FIELD.
 2. ALL DIMENSIONS ARE FROM FACE OF CURB UNLESS OTHERWISE NOTED.
 3. COORDINATE EXACT LOCATION OF SIDEWALKS AT DOORWAYS WITH ARCHITECTURAL PLANS.

- SITE PLAN DETAIL LEGEND**
- | | |
|---|--|
| 1 | STANDARD DUTY ASPHALT - SEE DETAIL XXXXXXX |
| 2 | CONCRETE CURB - SEE DETAIL XX/XXXX |
| 3 | CONCRETE SIDEWALK - SEE DETAIL XX/XXXX |
| 4 | CHAINLINK FENCE - SEE DETAIL XXXXXXX |
| 5 | UNIT PAVERS - SEE DETAIL XXXXXXX |
- SITE PLAN SHEET KEYNOTES**
- | | |
|---|--|
| 1 | 4" TOPSOIL & SEED IF NO PLANTINGS-SEE LANDSCAPING PLAN |
| 2 | MATCH EXISTING CURB OR RUN OUT IN 2'-0" |

- SITE PLAN LEGEND**
- | | |
|--|-------------------------------------|
| | APPROXIMATE PROPERTY LINE |
| | ASSUMED STREET MARGIN (R.O.W.) |
| | PROPOSED CONCRETE PAVEMENT/SIDEWALK |
| | PROPOSED CURB |
| | EDGE OF PAVEMENT |
| | LIGHTING FIXTURES |
| | SAW CUT LINE |
| | DETECTABLE WARNING SURFACE |

 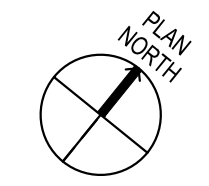

C&S Engineers, Inc.
141 Elm Street, Suite 100
Buffalo, New York 14203
Phone: 716-847-1630
Fax: 716-847-1454
www.cscos.com

CERTIFICATE OF AUTHORIZATION # 1021385
PRELIMINARY
NOT FOR CONSTRUCTION
REGISTRATION EXPIRES:

INSERT CLIENT LOGO,
SUBCONSULTANT LOGO, OR
REMOVE THIS AREA AND
RESIZE/CENTER THE
PROJECT IDENTIFICATION
BLOCK

**UPGRADE FACILITIES AT
VETERANS MEMORIAL PARK
372 NORTH MAIN STREET
ONEIDA, NEW YORK**


MARK	DATE	DESCRIPTION
REVISIONS		
PROJECT NO: E42.003.001		
DATE: JANUARY 6, 2026		
DRAWN BY: S.S.		
DESIGNED BY: V.O.		
CHECKED BY: CHECKED BY		
NO ALTERATION PERMITTED HEREON EXCEPT AS PROVIDED UNDER SECTION 7209 SUBDIVISION 2 OF THE NEW YORK EDUCATION LAW		


**PICKLEBALL &
BASKET BALL COURT
SITE PLAN**

CS102




 SCALE: 1"=10'


PLANT_SCHEDULE						
SYMBOL	CODE	BOTANICAL / COMMON NAME	SIZE	CONTAINER	QTY	REMARKS
TREES						
	MA	Malus x 'Adirondack' / Adirondack Crabapple	1.5" Cal.	B&B	6	
SHRUBS						
	SB	Spiraea x bumalda 'Goldflame' / Goldflame Spirea	#5	Cont	20	

 


Copyright ©

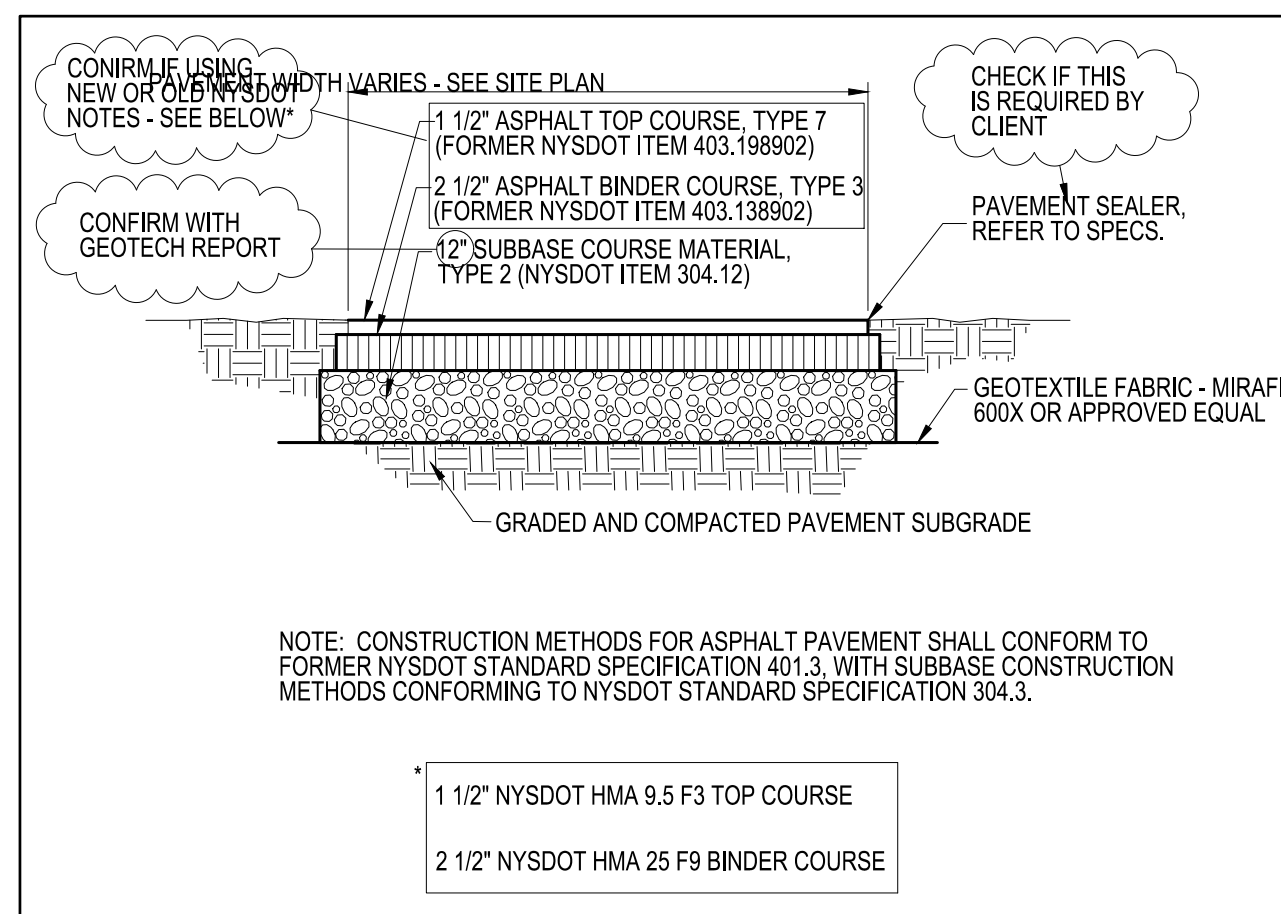

D1	ASPHALT PAVEMENT SECTION
	SCALE: NTS

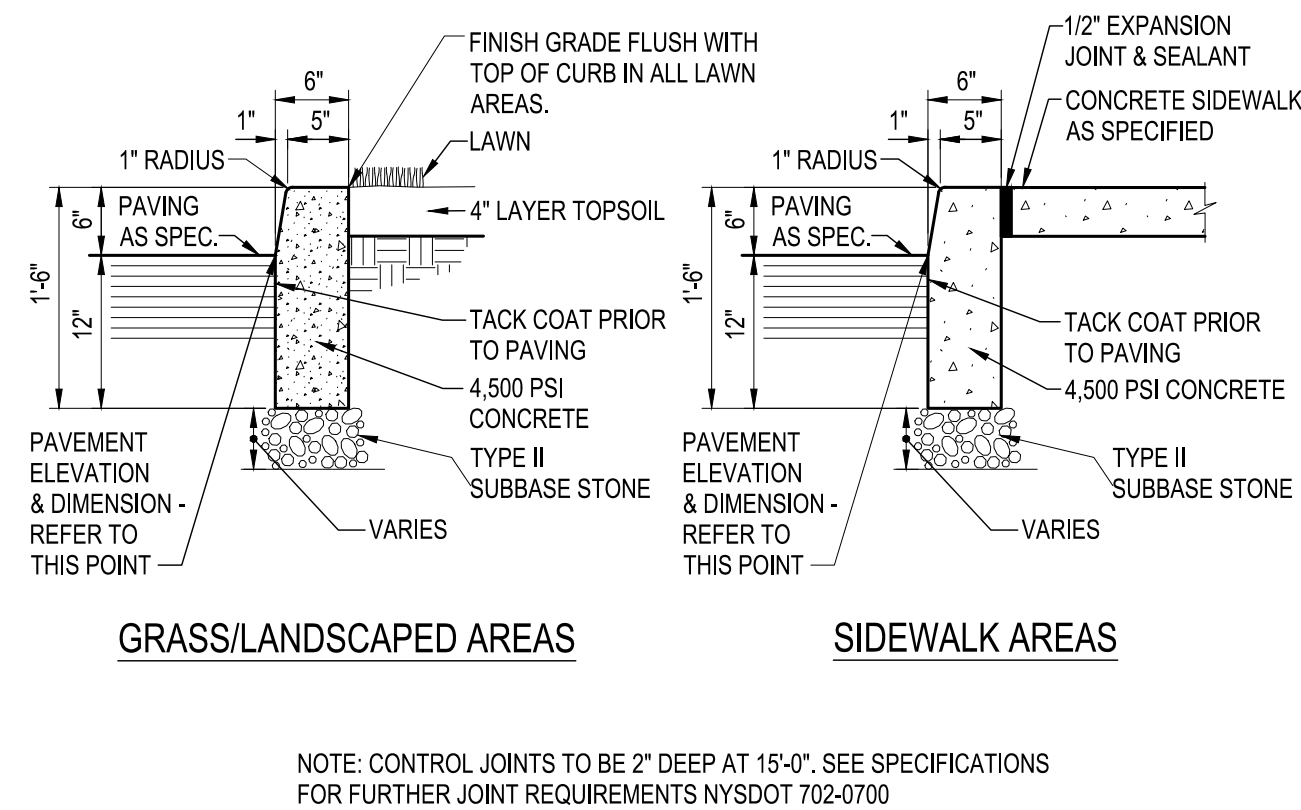

C1	CONCRETE CURB
	SCALE: NTS

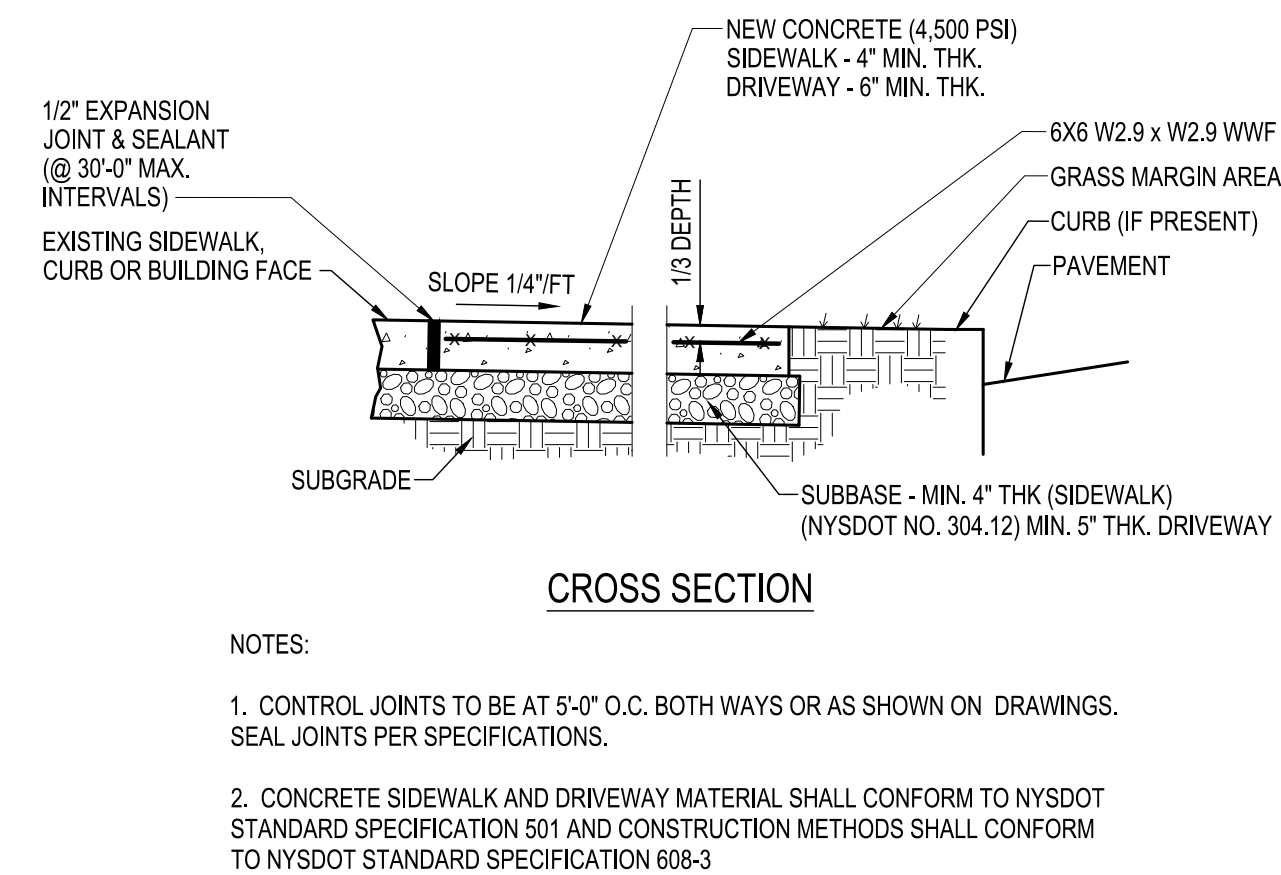

B1	CONCRETE SIDEWALK
	SCALE: NTS

A1	NOT USED
	SCALE: NTS

D2	NOT USED
	SCALE: NTS

C2	NOT USED
	SCALE: NTS

B2	NOT USED
	SCALE: NTS

A2	NOT USED
	SCALE: NTS

D3	NOT USED
	SCALE: NTS

C3	NOT USED
	SCALE: NTS

B3	NOT USED
	SCALE: NTS

A3	NOT USED
	SCALE: NTS

D4	NOT USED
	SCALE: NTS

C4	NOT USED
	SCALE: NTS

B4	NOT USED
	SCALE: NTS

A4	NOT USED
	SCALE: NTS



C&S Engineers, Inc.
141 Elm Street, Suite 100
Buffalo, New York 14203
Phone: 716-847-1630
Fax: 716-847-1454
www.cscos.com

CERTIFICATE OF AUTHORIZATION #: 002 365

PRELIMINARY
NOT FOR
CONSTRUCTION

REGISTRATION EXPIRES:


~~INSERT CLIENT LOGO,
SUBCONSULTANT LOGO, OR
REMOVE THIS AREA AND
RESIZE/CENTER THE
PROJECT IDENTIFICATION
BLOCK~~

**UPGRADE FACILITIES AT
VETERANS MEMORIAL PARK
372 NORTH MAIN STREET
ONEIDA, NEW YORK**

MARK	DATE	DESCRIPTION
REVISIONS		
PROJECT NO:	E42.003.001	
DATE:	JANUARY 6, 2026	
DRAWN BY:	DRAWN BY	
DESIGNED BY:	DESIGNED BY	
CHECKED BY:	CHECKED BY	
NO ALTERATION PERMITTED HEREON EXCEPT AS PROVIDED UNDER SECTION 7209 SUBDIVISION 2 OF THE NEW YORK EDUCATION LAW		

SITE DETAILS

CS501

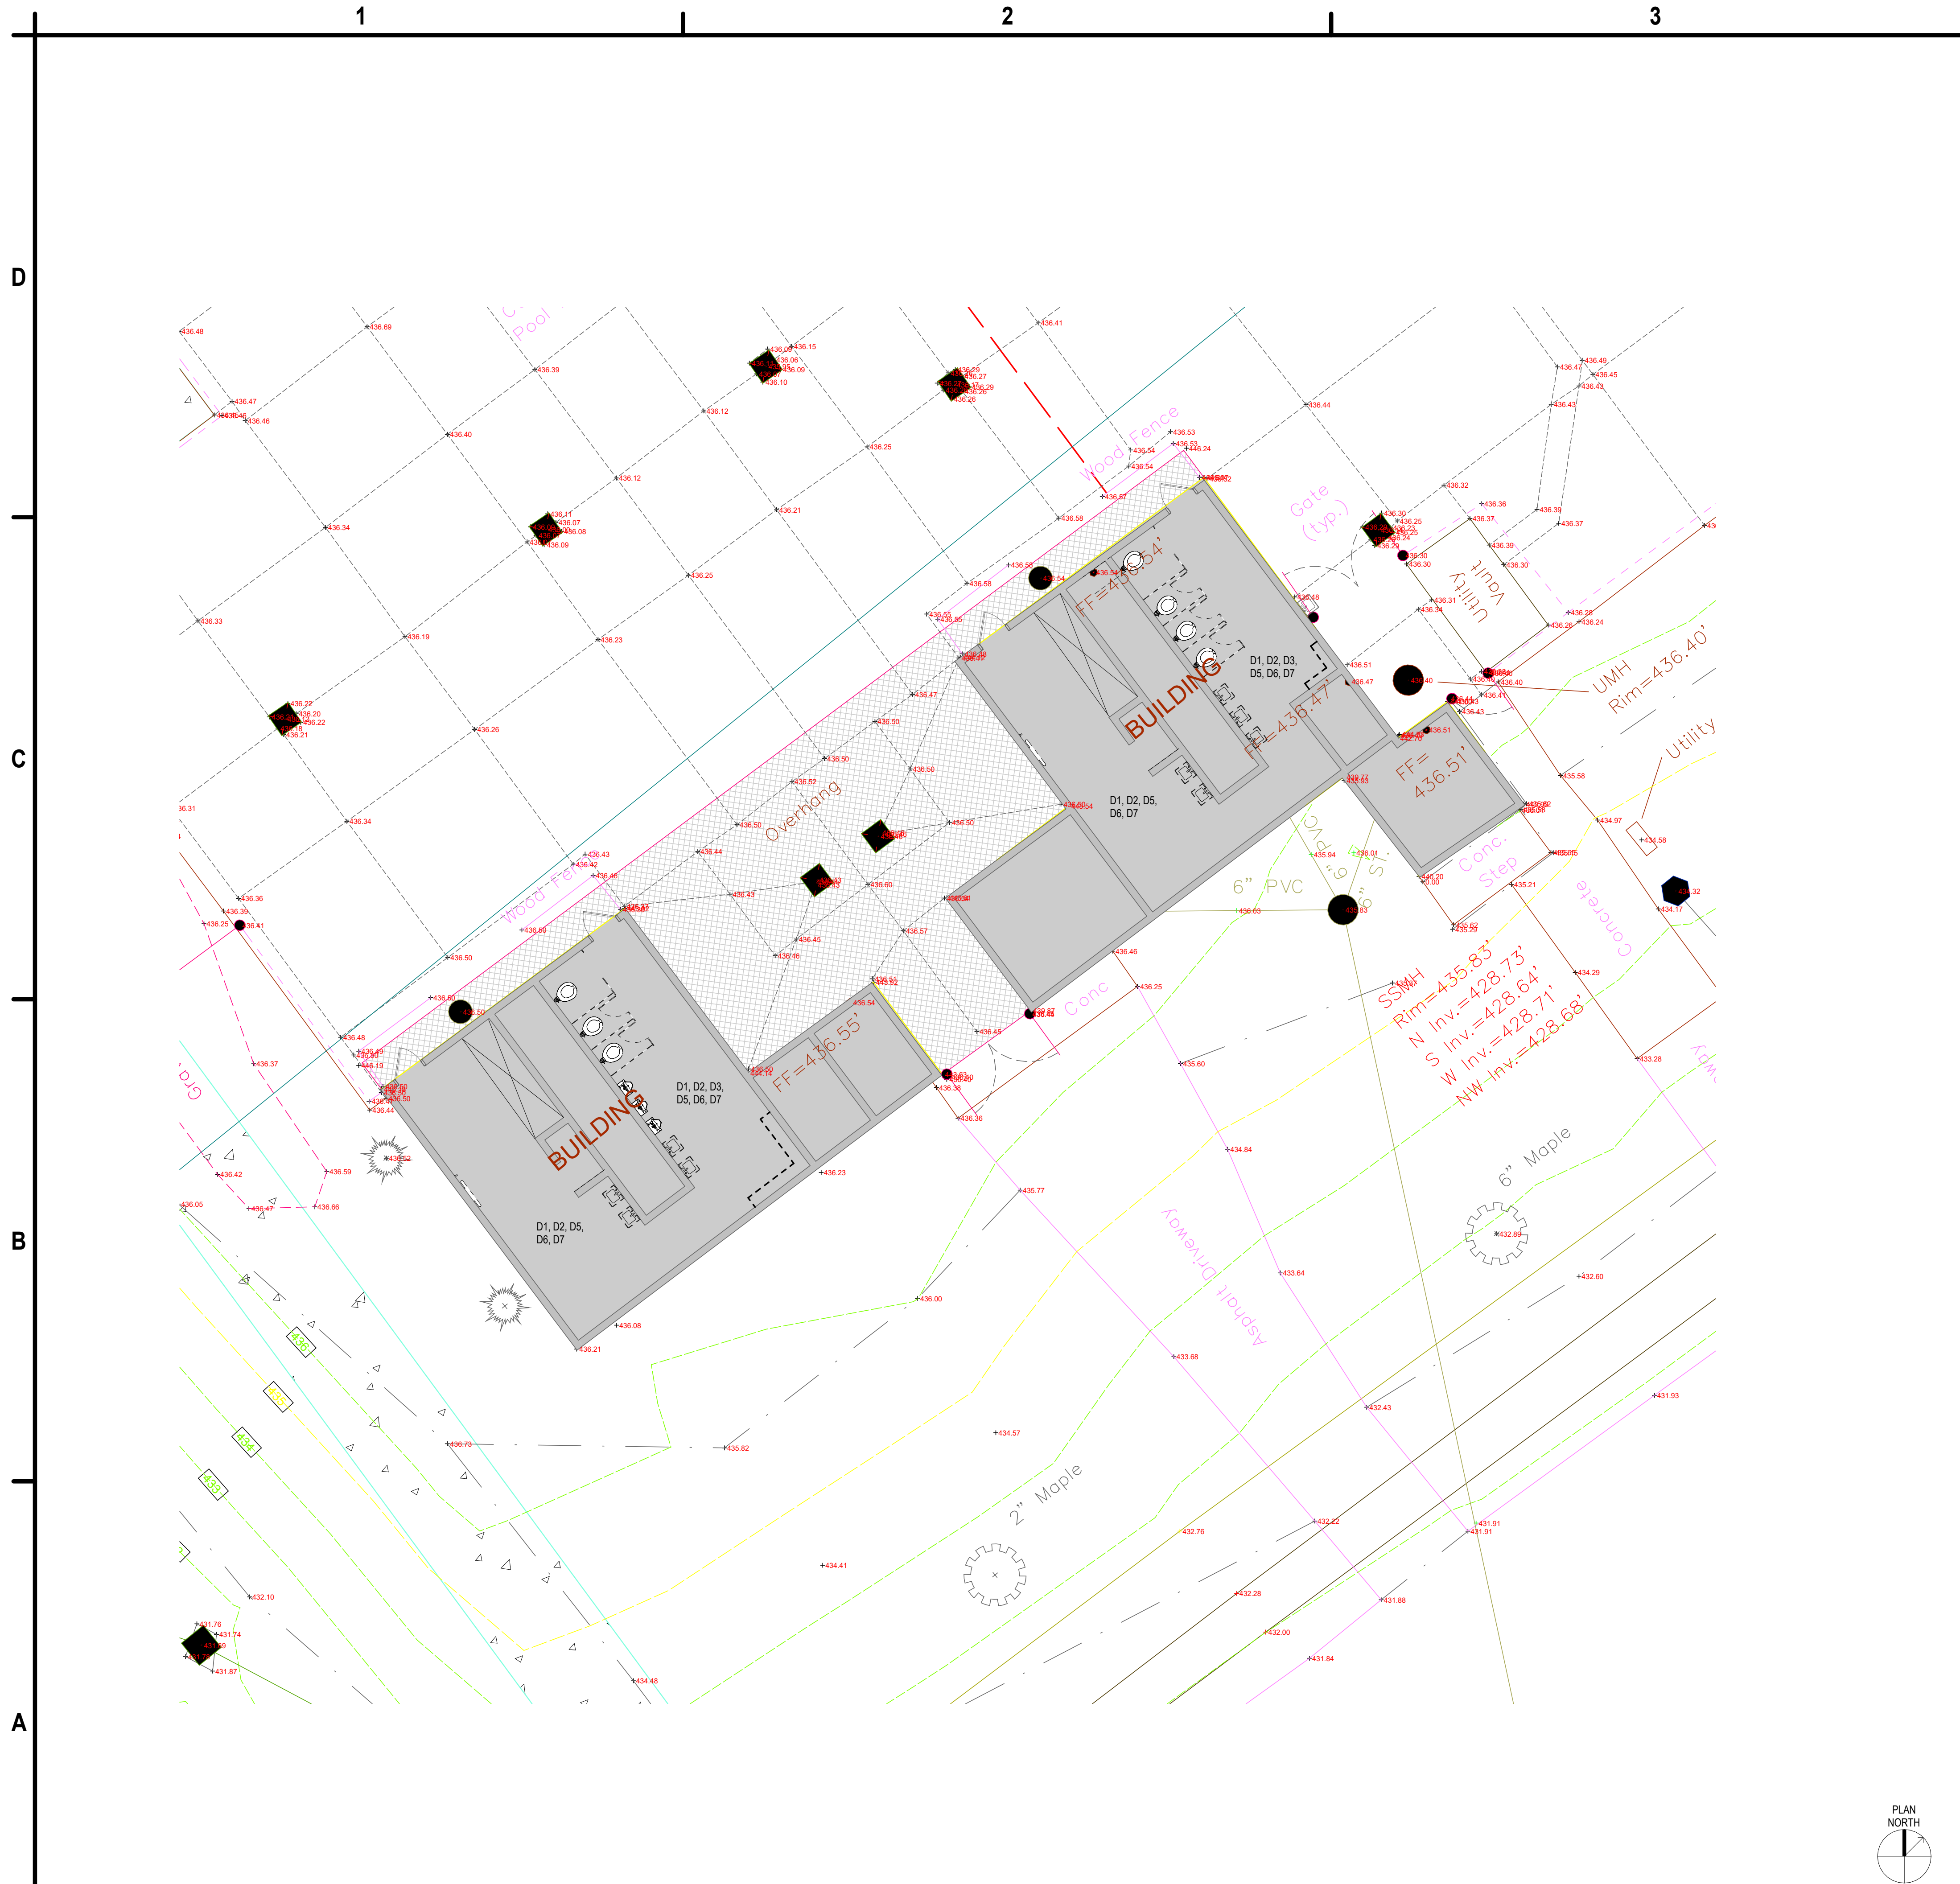

- GENERAL DEMOLITION NOTES**
- 1 PROTECT ALL EXISTING FINISH SURFACES TO REMAIN. PATCH EXISTING CONSTRUCTION TO MATCH ADJACENT FINISHES IN THE CASE OF REMOVALS AS REQUIRED BY THE WORK. ALL DAMAGE CAUSED BY THE CONTRACTOR, WHETHER INSIDE OR OUTSIDE THE CONTRACT LIMIT, SHALL BE REPLACED OR REPAIRED TO A LIKE NEW CONDITION AT NO ADDITIONAL COST TO THE OWNER.
 - 2 REMOVE EXISTING FLOORING AT AREAS DESIGNATED TO RECEIVE FLOORING. PROVIDE SMOOTH, FLUSH AND LEVEL FLOOR TO EXTENT REQUIRED TO RECEIVE FINISHES. PATCH AND LEVEL FLOOR THROUGHOUT.
 - 3 REFER TO CIVIL, STRUCTURAL, PLUMBING, MECHANICAL, ELECTRICAL, AND FIRE PROTECTION DRAWINGS FOR ELEMENTS TO BE DEMOLISHED WITHIN THE SCOPE OF THOSE DISCIPLINES. COORDINATE DEMOLITION WITH THIS RELATED WORK.
 - 4 RECYCLE ALL METAL TO BE REMOVED INCLUDING, BUT NOT LIMITED TO: FRAMING, PIPE AND CEILING GRID.
 - 5 IT IS THE INTENT OF THE DEMOLITION PLAN TO SHOW THE GENERAL NATURE OF THE DEMOLITION SCOPE OF WORK. THE GENERAL CONTRACTOR IS RESPONSIBLE FOR VISITING THE JOB SITE AND VERIFYING THE EXISTING CONDITIONS. THE GENERAL CONTRACTOR SHALL NOTIFY THE ARCHITECT IMMEDIATELY OF ANY DISCREPANCIES.
 - 6 COORDINATE AND VERIFY WITH THE OWNER ALL ITEMS TO BE SALVAGED PRIOR TO REMOVAL. THESE ITEMS MAY INCLUDE, BUT ARE NOT LIMITED TO: THE FOLLOWING: LIGHT FIXTURES, DOORS/FRAMES AND HARDWARE, CASEWORK, PLUMBING FIXTURES.
 - 7 MAINTAIN SEPARATION BETWEEN AREAS OUTSIDE THE SCOPE OF WORK BY PROVIDING PLASTIC SHEATHING BETWEEN SPACES AND/OR TEMPORARILY TAPING OF JOINTS AND CAPS TO PREVENT DUST MIGRATION.
 - 8 CONDUCT DEMOLITION AND THE REMOVAL OF DEBRIS TO ENSURE MINIMUM INTERFERENCE WITH STREETS, WALKS AND OTHER ADJACENT OCCUPIED BUILDING. COMPLY WITH LOCAL JURISDICTIONAL REQUIREMENTS OR RECYCLING AND TREATMENT OF ITEMS TO BE RECYCLED.
 - 9 DISPOSE OF ALL DEMOLISHED OR REMOVED MATERIALS LEGALLY OFF THE SITE. COMPLY WITH ALL LOCAL HAULING AND DISPOSAL REQUIREMENTS.
 - 10 UTILITIES TO REMAIN IN SERVICE DURING DEMOLITION SHALL BE MAINTAINED AND PROTECTED AGAINST DAMAGE.
 - 11 SCHEDULE ALL SERVICE SHUT-DOWNS WITH THE OWNER. NOTIFY THE OWNER A MINIMUM TIME OF ONE (1) WEEK AND ADDITIONALLY ONE (1) HOUR PRIOR TO SHUT DOWNS.
 - 12 UPON COMPLETION, CLEAN THE ENTIRE WORK AREA TO A TIDY, UNIFORM CONDITION; REMOVING ALL DEBRIS, DUST PARTITIONS AND ASSOCIATED MATERIALS USED DURING DEMOLITION. CLEAN ALL AREAS IMPACTED BY DEMOLITION, INCLUDING BUT NOT LIMITED TO ADJACENT OCCUPIED AREAS AND AREAS NOT WITHIN THE SCOPE OF WORK.
 - 13 ABANDONMENT OF ITEMS OR UNUSED UTILITIES IN PLACE IS STRICTLY PROHIBITED, UNLESS SPECIFICALLY PERMITTED BY OWNER.
 - 14 DISPOSAL OF ALL DEBRIS AND DEMOLISHED MATERIALS SHALL BE CONTRACTORS RESPONSIBILITY. DEBRIS REMOVAL SHALL BE PROMPT AND GENERAL CLEAN-UP SHALL OCCUR DAILY.
 - 15 IT IS THE CONTRACTOR'S RESPONSIBILITY TO COORDINATE SELECTIVE DEMOLITION WORK AND ALL NEW WORK TO ASSURE THAT THE BUILDING REMAINS WEATHERTIGHT; PROVIDE TEMPORARY PROTECTION AS NEEDED.
 - 16 CLEAN AND PREPARE ALL EXISTING SURFACES TO REMAIN AS REQUIRED TO PREPARE FOR PROPOSED FINISHES.
 - 17 IT IS NOT EXPECTED THAT HAZARDOUS MATERIALS WILL BE ENCOUNTERED IN THE WORK. IF SUSPECTED HAZARDOUS MATERIALS ARE ENCOUNTERED, DO NOT DISTURB; IMMEDIATELY NOTIFY ARCHITECT AND OWNER.
 - 18 PLUMBING DRAWINGS, INCLUDING DEMOLITION WORK AND GENERAL NOTES PROVIDED AS DESIGN DEVELOPS.
 - X GENERAL: PLACE AN "X" IN THE NOTE NUMBER FOR ALL NOTES YOU DON'T WANT AND RENUMBER THE REMAINING NOTES.
 - X REMOVE ALL WALLS AND FINISHES DOWN TO STRUCTURAL STEEL AND CONCRETE FLOORS, UNLESS OTHERWISE NOTED, AS REQUIRED TO ACCOMMODATE THE WORK. COORDINATE ALL NECESSARY DEMOLITION WORK WITH THE NEW WORK.
 - X REMOVE ALL METAL FRAMED PARTITIONS, DOORS, WINDOWS, AND FRAMES AS INDICATED. REMOVE WALL ACCESSORIES INCLUDING BUT NOT LIMITED TO: SIGNAGE, TACK AND WHITE BOARDS, RECESSED METAL TRASH AND MEDICAL GAS UNITS. SALVAGE TO OWNER: THE FOLLOWING: WOOD WINDOWS, LOCKERS, MEDICAL EQUIPMENT LOCKERS, TELEVISION, COMPUTER, AND SHELVING BRACKETS, CLOCKS, ARTWORK, SECURITY CAMERAS AND DEVICES, HAND SANITIZERS, MEDICAL SHARPS DISPOSAL CONTAINERS, VIEW BOXES, PHONES, AND FIRE EXTINGUISHERS.
 - X PROTECT/MAINTAIN ALL EXISTING FIRE PROTECTION AND FIRE RESISTANCE RATED CONSTRUCTION.
 - X RECYCLE ALL WOOD TO BE REMOVED INCLUDING, BUT NOT LIMITED TO: BLOCKING, CASEWORK AND SHELVING.
 - X RECYCLE ALL GLASS TO BE REMOVED.
 - X RECYCLE ALL ACOUSTIC CEILING PANELS TO BE REMOVED.
 - X LEGALLY DISPOSE OF ALL REMOVED BRICK AND BLOCK AS CLEAN FILL, EITHER ON OR OFF SITE.
 - X RECYCLE ALL GYPSUM BOARD TO BE REMOVED.
 - X FIRE AND SMOKE DETECTION DEVICES SHALL REMAIN OPERATIONAL DURING DEMOLITION AND CONSTRUCTION. PROTECT FIRE AND SMOKE DETECTION DEVICES FROM DUST, DAMAGE AND DEBRIS.

- KEYED DEMOLITION NOTES**
- D1 PATCH ALL FLOORS AS REQUIRED TO PREPARE THE SURFACE TO RECEIVE THE FINISH FLOOR COVERING.
 - D2 SMOOTH AND PREPARE WALL SURFACES FOR NEW FINISH.
 - D3 REMOVE TOILET PARTITION SYSTEM, AND URINAL SCREENS WHERE APPLICABLE.
 - D4 SMOOTH AND PREPARE METAL DOOR, PARTITION, AND FRAME FOR NEW PAINT.
 - D5 REMOVE PLUMBING FIXTURES. ADDITIONAL DEMO NOTES TO BE COORDINATED ON PLUMBING DRAWINGS.
 - D6 REMOVE TOILET ACCESSORIES INCLUDING BUT NOT LIMITED TO: PAPER TOWEL DISPENSERS, SOAP DISPENSERS, SANITARY NAPKIN DISPENSERS, TOILET PAPER HOLDERS.
 - D7 STRIP AND PATCH AND REPAIR DOOR FRAMES TO RECEIVE NEW PAINTED FINISH.

A1 MAIN BUILDING, RESTROOMS DEMOLITION PLAN
SCALE: 1/8" = 1'-0"

A4 KEYED AND GENERAL DEMOLITION NOTES
SCALE: NOT TO SCALE



C&S Architects & Engineers, LLC
499 Col. Eileen Collins Blvd
Syracuse, New York 13212
Phone: 315-455-2000
Fax: 315-455-9667
www.cscos.com


PRELIMINARY
NOT FOR CONSTRUCTION

VETERANS MEMORIAL PARK DRI
CITY OF ONEIDA
372 NORTH MAIN STREET
ONEIDA, NEW YORK 13421

MARK	DATE	DESCRIPTION
REVISIONS		
PROJECT NO:	E42.003.001	
DATE:	12/22/2025	
DRAWN BY:	ASHERMAN	
DESIGNED BY:	ASHERMAN	
CHECKED BY:	Checker	
NO ALTERATION PERMITTED HEREON EXCEPT AS PROVIDED UNDER SECTION 7209 SUBDIVISION 2 OF THE NEW YORK EDUCATION LAW		

MAIN BUILDING, RESTROOM DEMOLITION PLAN

AD-101

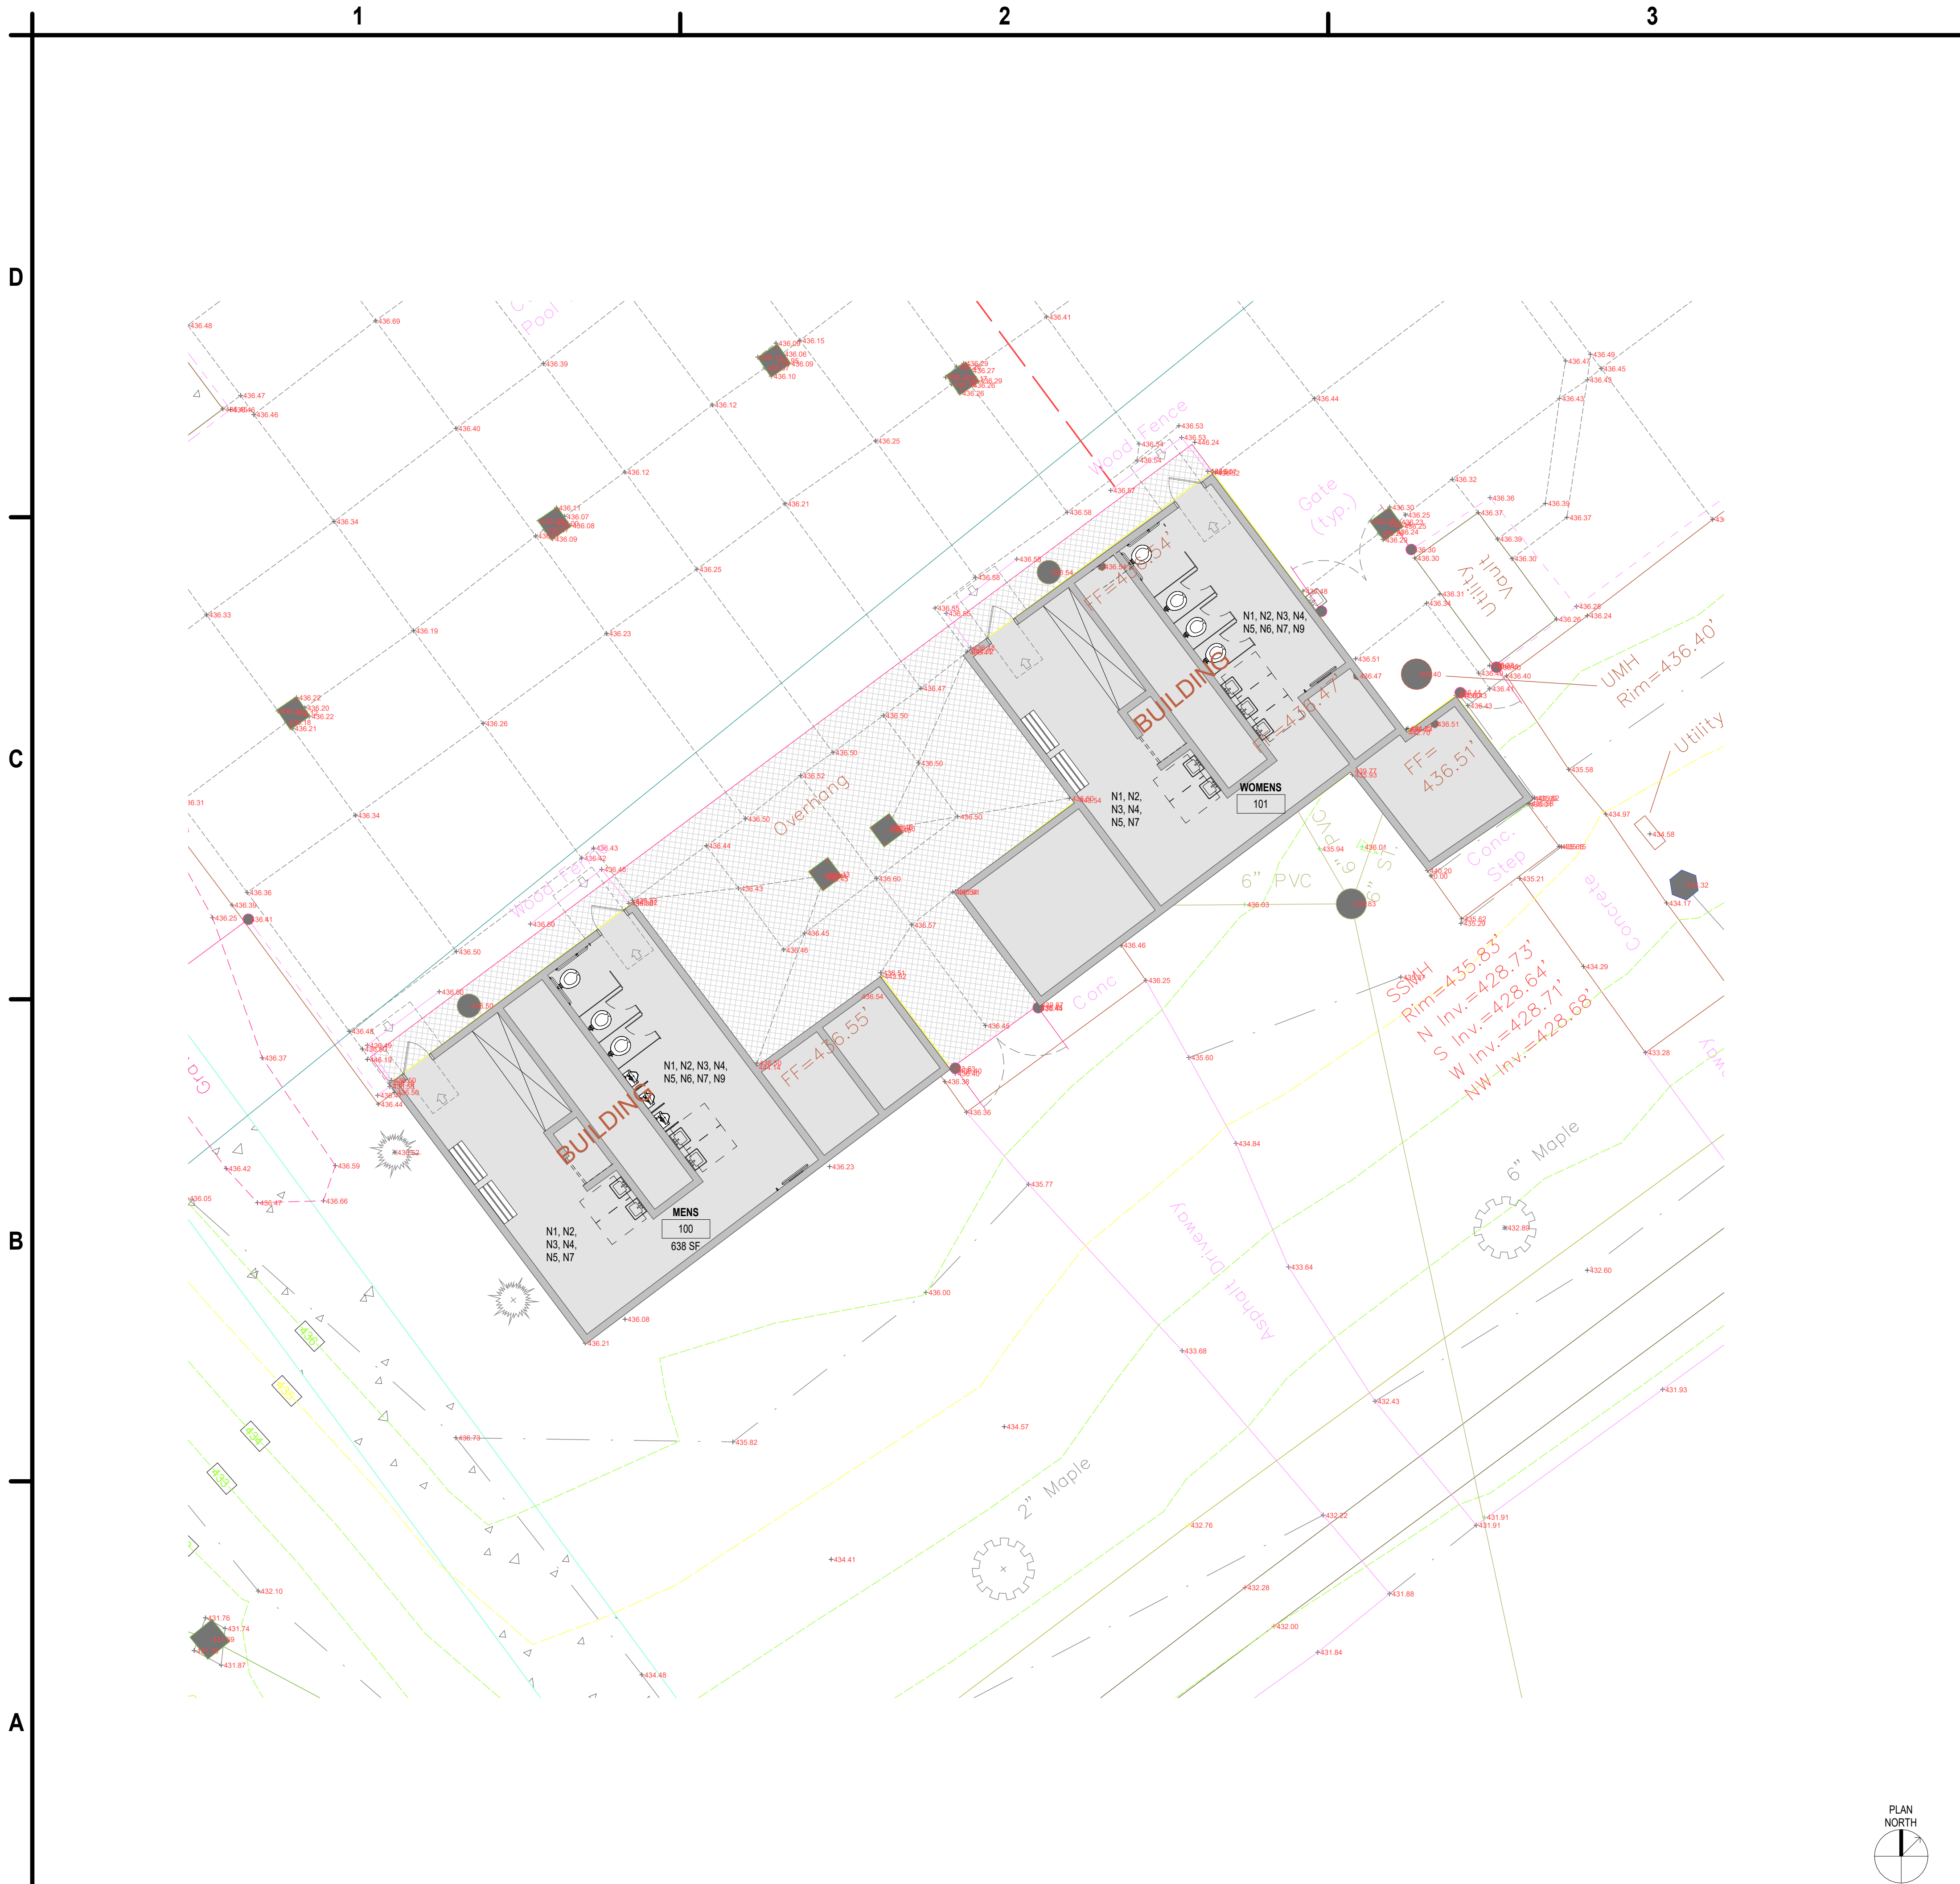

- KEYED NOTES**
- N1 PROVIDE NEW PAINT AT ALL WALL SURFACES.
 - N2 NEW FLOOR FINISH, AS REQUIRED.
 - N3 PROVIDE NEW PLUMBING FIXTURES TO INCLUDE TOILETS, URINALS, SINKS. ADA COMPLIANT FIXTURE HEIGHT REQUIRED.
 - N4 PROVIDE TAMPER PROOF WALL MIRRORS, SOAP DISPENSERS, TOILET PAPER DISPENSERS, AND TOILET PAPER HOLDERS.
 - N5 FILL AND SEAL ALL SPACING FROM WALL TO FLOOR FINISH. SEALANT TO BE HIGH PERFORMANCE FINISH.
 - N6 INSTALL NEW WALL MOUNTED BENCH.
 - N7 RECONSTRUCT, FILL, PATCH, AND PAINT DOORS AND ENTRANCES
 - N8 PAINT TOILET PARTITION AND DOOR
 - N9 NEW TOILET PARTITIONS AND URINAL SCREENS

- D4 KEYED NOTES**
SCALE: NOT TO SCALE
- GENERAL FINISH NOTES**
- 1 ALL WALLS TO BE PAINTED P1 UNLESS OTHERWISE NOTED
 - 3 PAINT ALL PREVIOUSLY PAINTED SURFACES WITHIN CONTRACT LIMIT LINE
 - 4 PAINT ALL PREVIOUSLY PAINTED ACCENT PAINT FOR WALL BASE P1, UNLESS OTHERWISE NOTED
 - 5 PATTERN NAME, COLOR AND NUMBER FOR EACH MATERIAL ARE LISTED ON THE FINISH SCHEDULE. IT SHALL BE THE RESPONSIBILITY OF THE CONTRACTOR TO BRING ANY DISCREPANCIES TO THE ATTENTION OF THE ARCHITECT SO THAT THE CORRECT MATERIAL IS INSTALLED
 - 6 MISCELLANEOUS ELECTRICAL PANEL COVERS, GRILLES, ETC. TO BE PAINTED TO MATCH ADJACENT WALL SURFACES, UNLESS OTHERWISE NOTED
 - 7 ADHESIVES AND FINISHES TO BE LOW VOC
 - 8 PROVIDE (1) ROBE HOOK MOUNTED AT 5'-6" AFF AND (1) MOUNTED AT 4'-0" AFF AT EACH TOILET ROOM DOOR. CENTER HOOK ON INSIDE OF DOOR



C&S Architects & Engineers, LLC
499 Col. Eileen Collins Blvd
Syracuse, New York 13212
Phone: 315-455-2000
Fax: 315-455-9667
www.cscos.com



PRELIMINARY
NOT FOR CONSTRUCTION

VETERANS MEMORIAL PARK DRI
CITY OF ONEIDA
372 NORTH MAIN STREET
ONEIDA, NEW YORK 13421

MARK	DATE	DESCRIPTION
REVISIONS		
PROJECT NO:	E42.003.001	
DATE:	12/22/2025	
DRAWN BY:	ASHERMAN	
DESIGNED BY:	ASHERMAN	
CHECKED BY:	Checker	
NO ALTERATION PERMITTED HEREON EXCEPT AS PROVIDED UNDER SECTION 7209 SUBDIVISION 2 OF THE NEW YORK EDUCATION LAW		

MAIN BUILDING, RESTROOM FLOOR PLAN

A-101

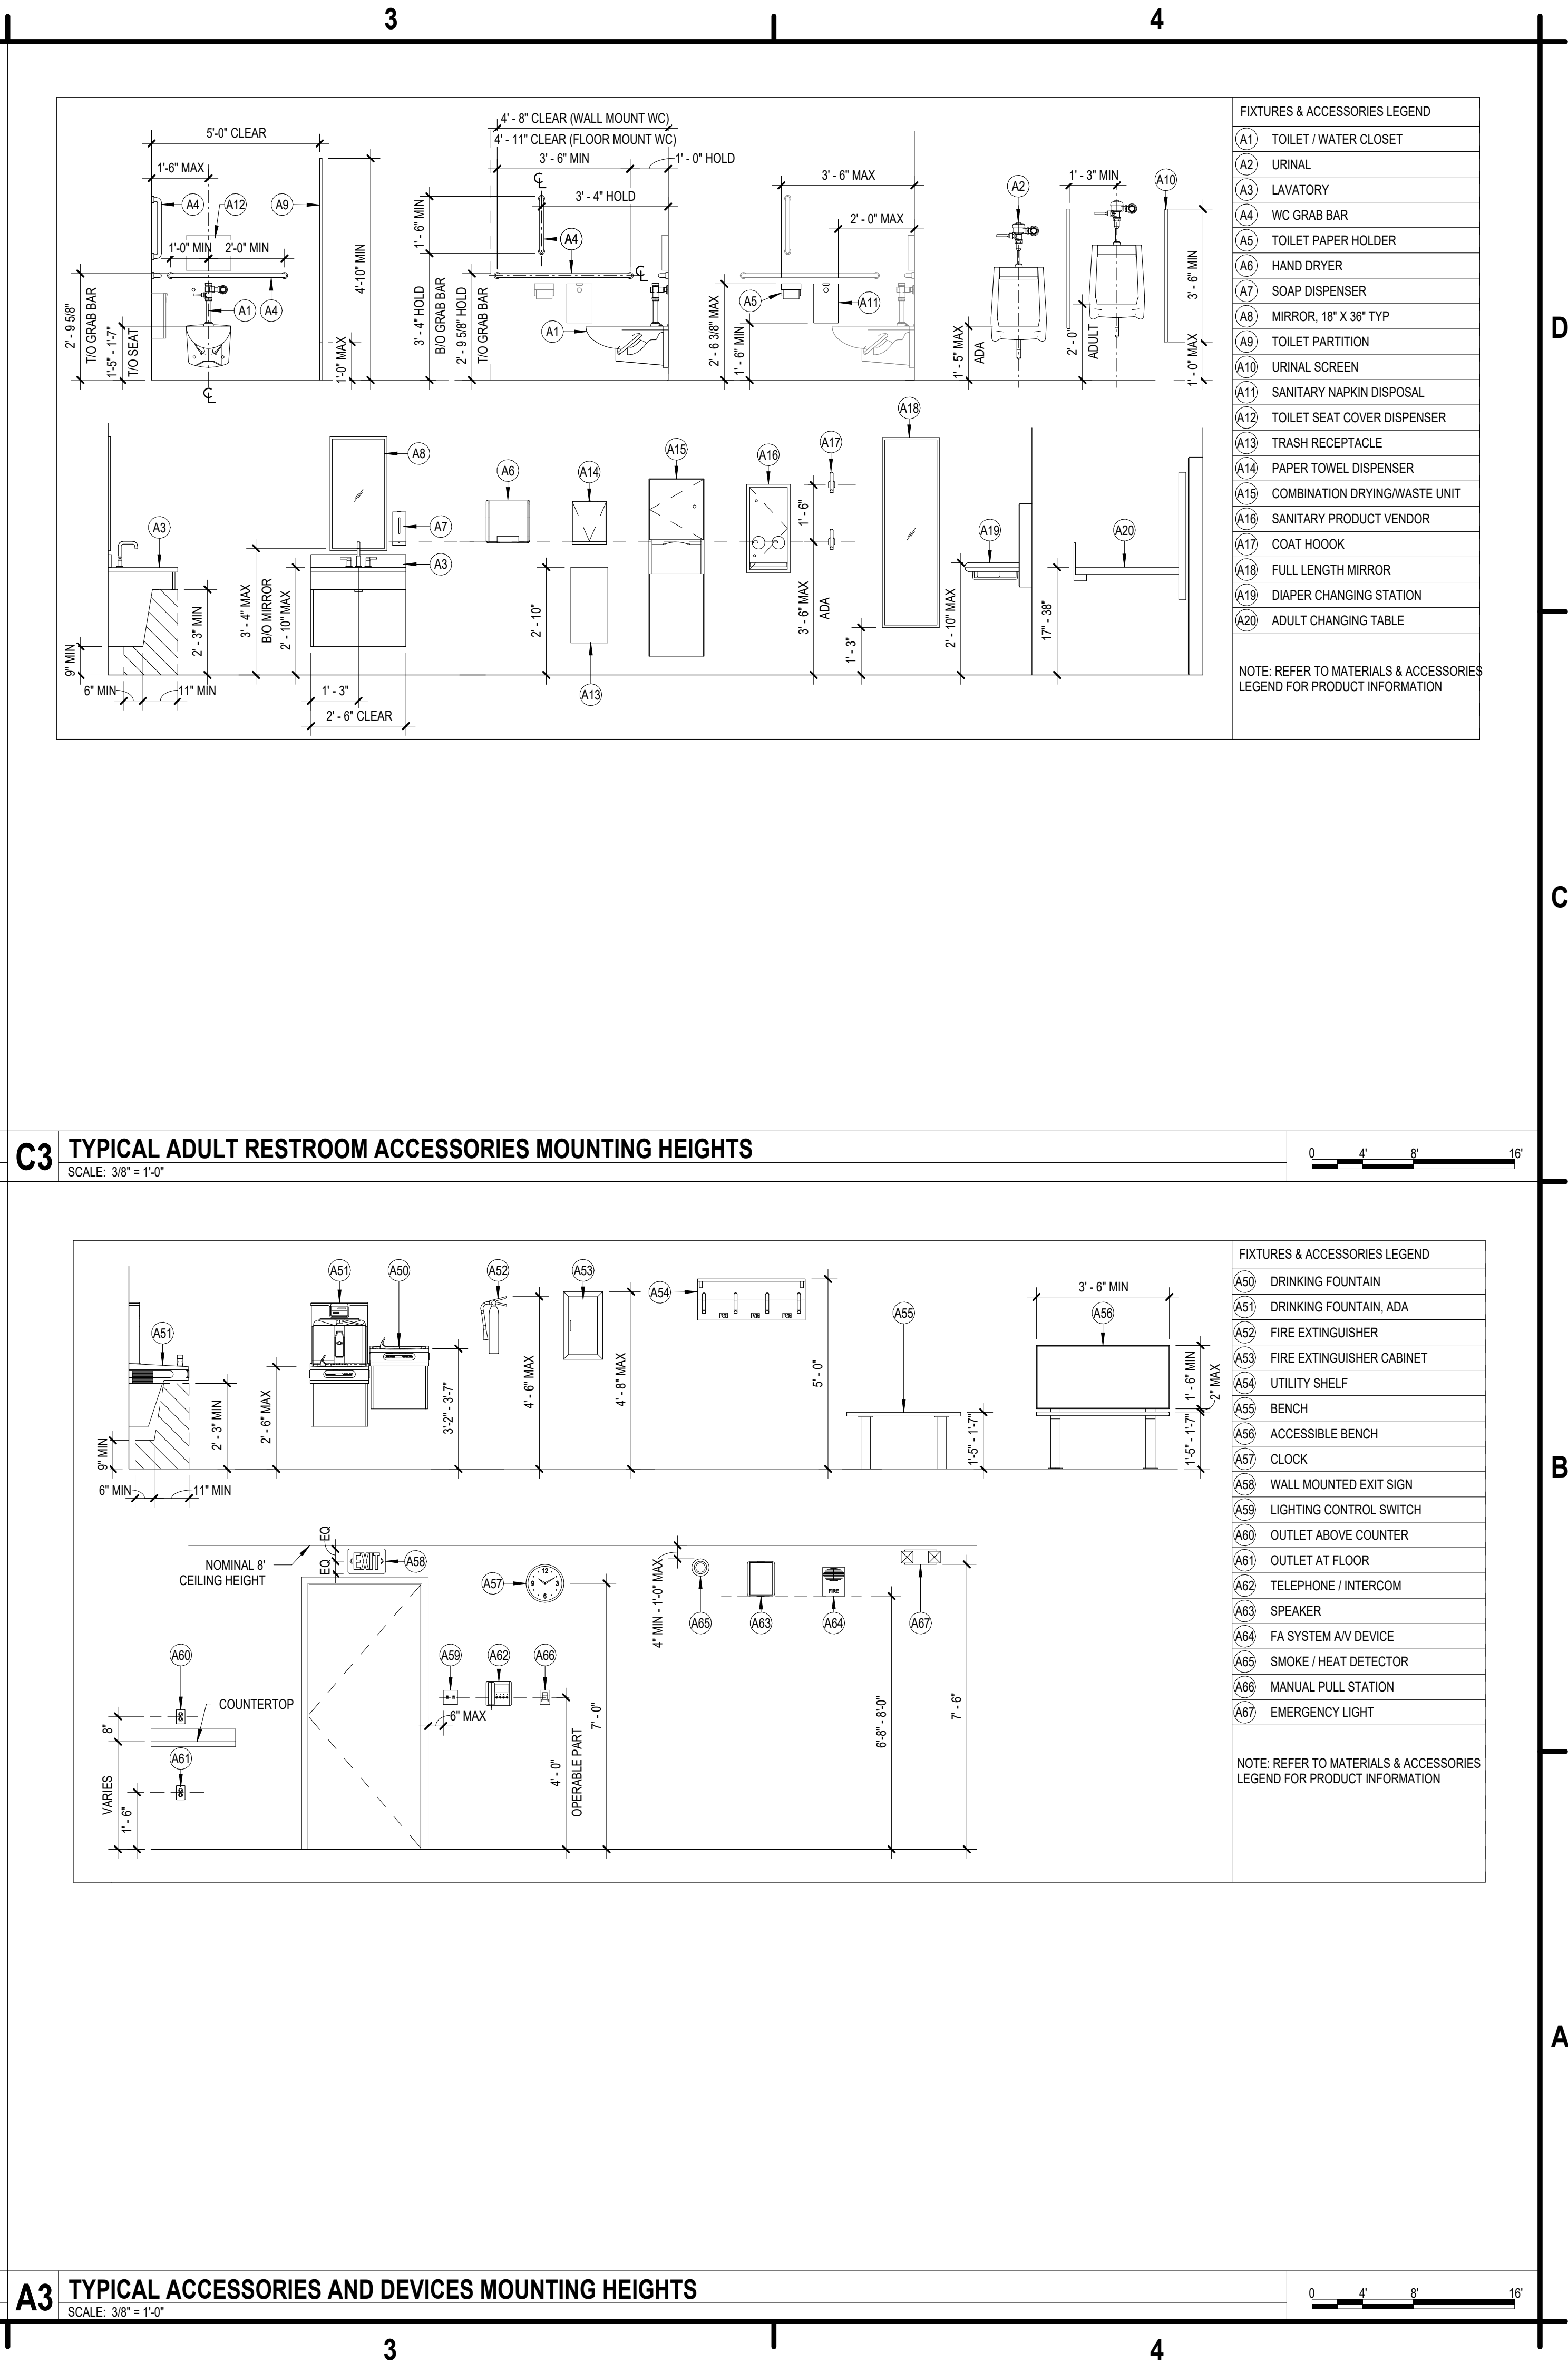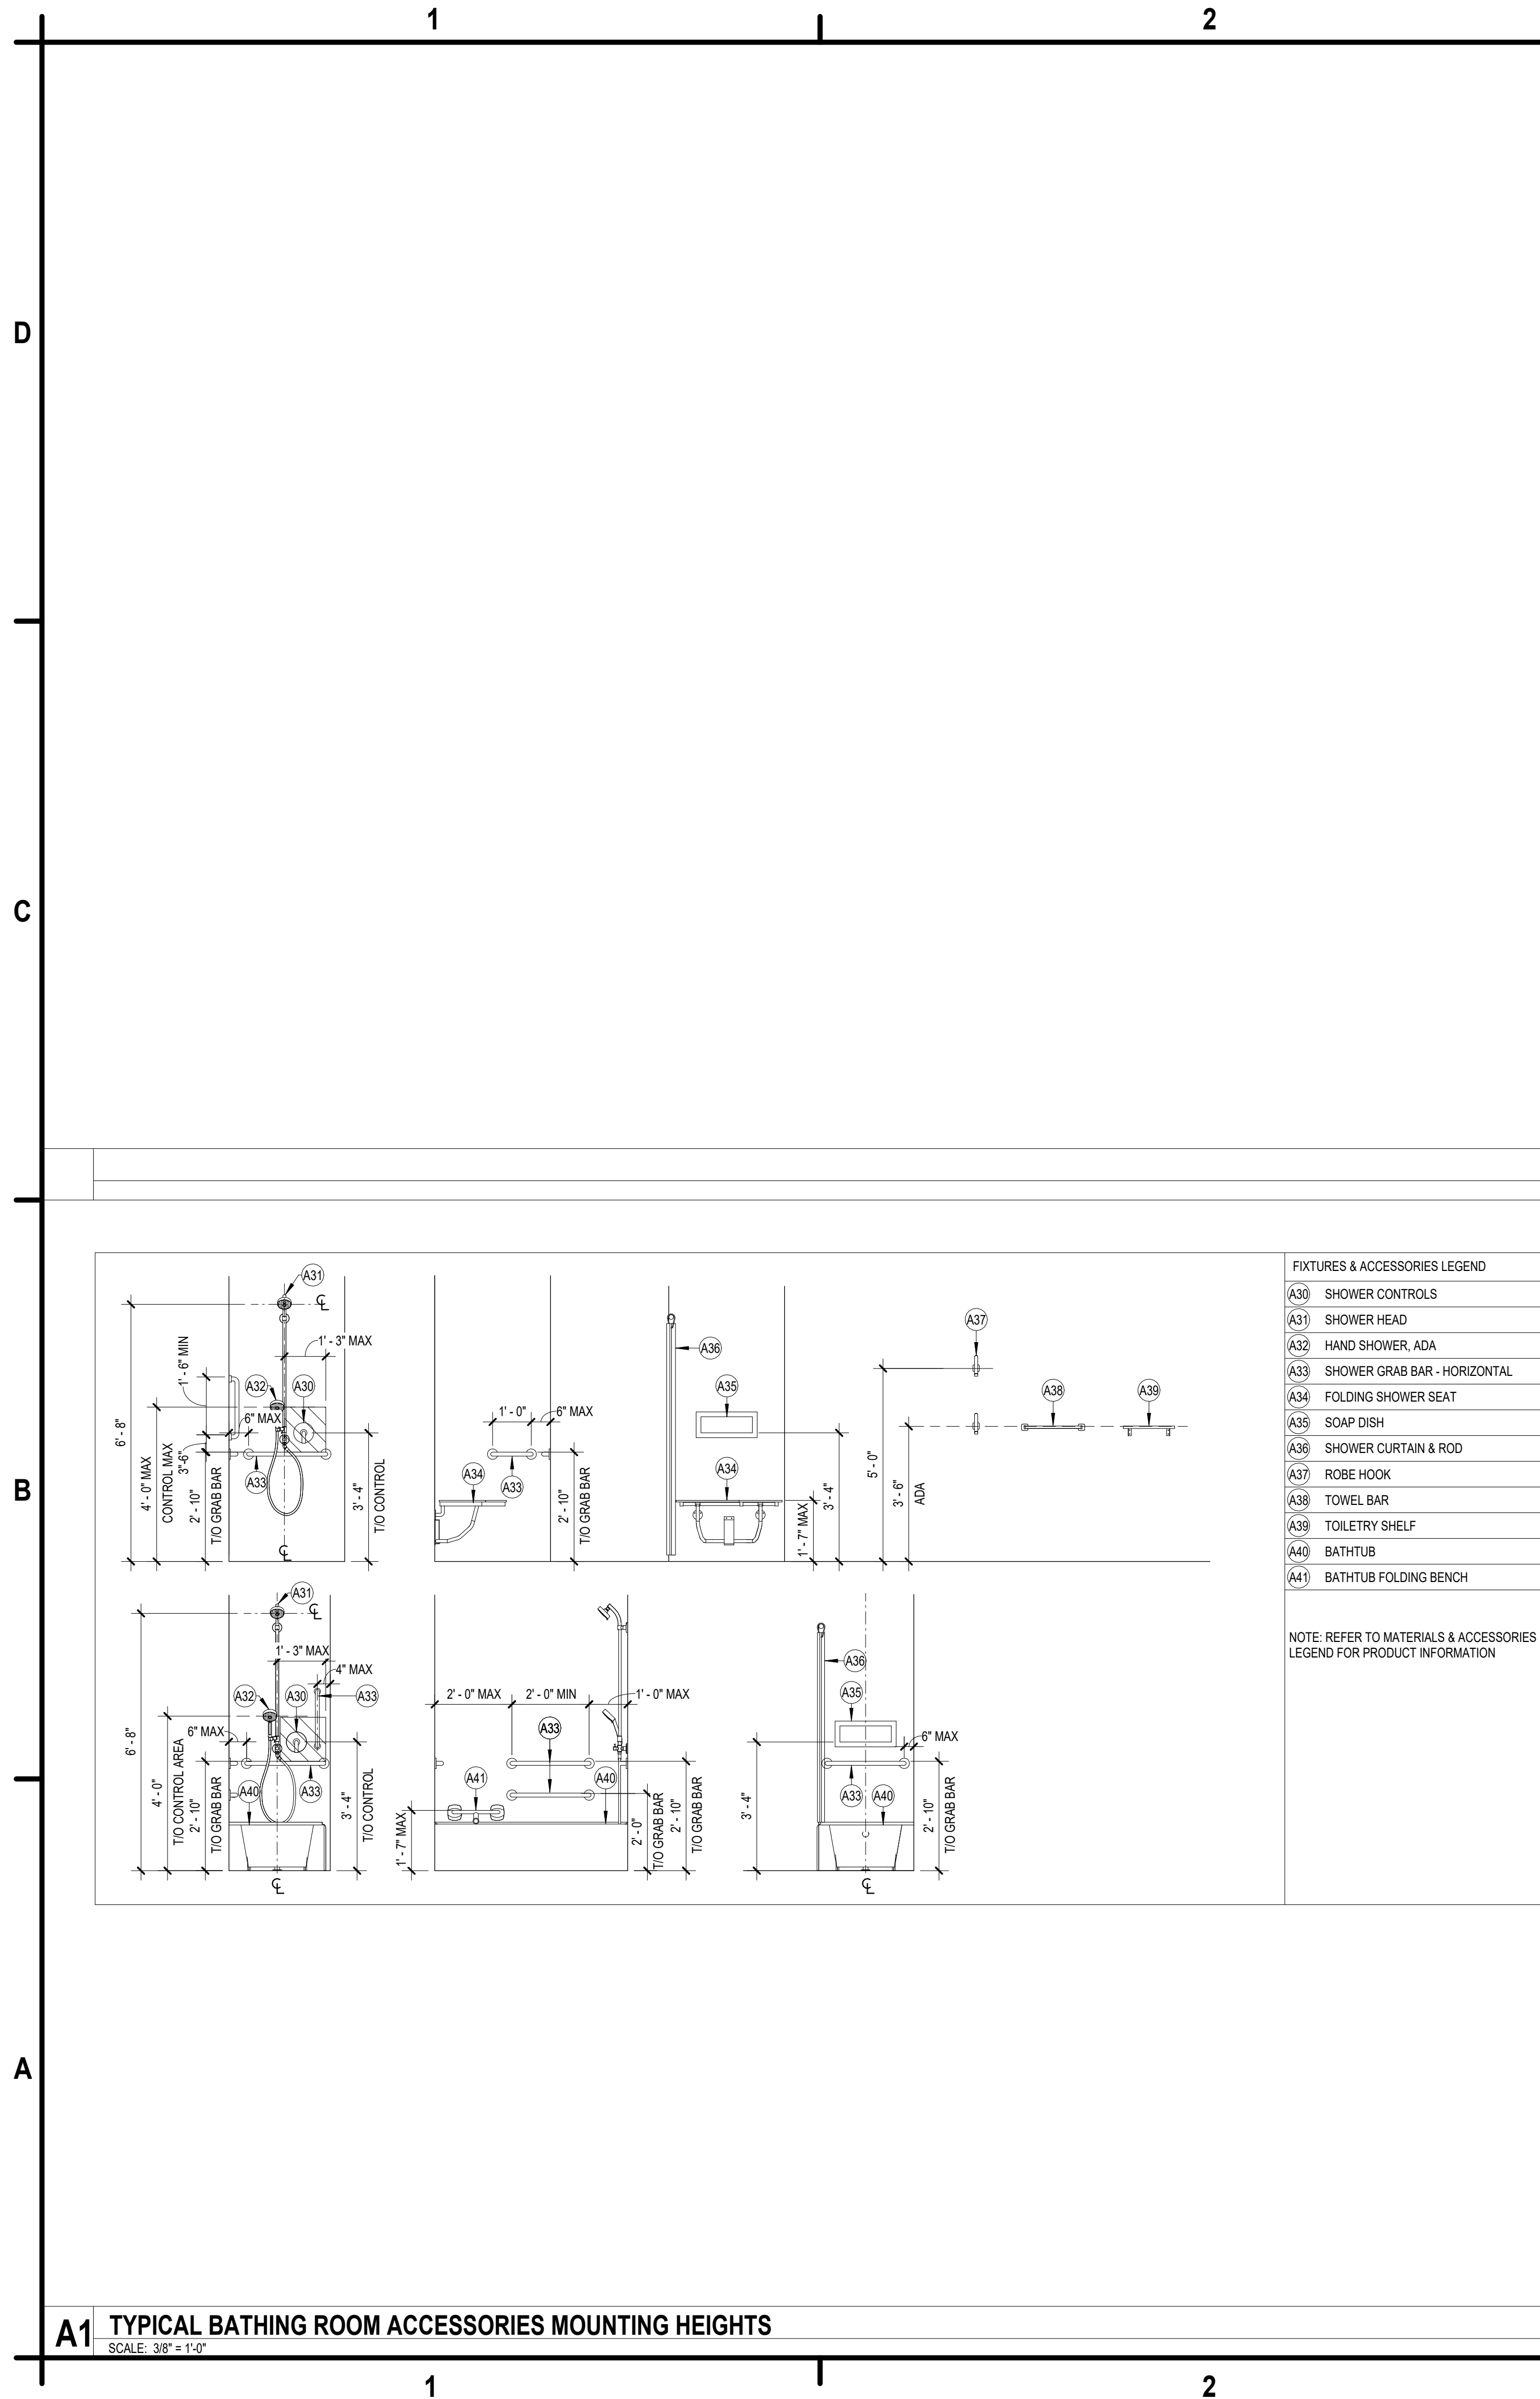

C&S Architects & Engineers, LLC
499 Col. Eileen Collins Blvd
Syracuse, New York 13212
Phone: 315-455-2000
Fax: 315-455-9667
www.cscos.com

PRELIMINARY
NOT FOR CONSTRUCTION

VETERANS MEMORIAL PARK DRI
CITY OF ONEIDA
372 NORTH MAIN STREET
ONEIDA, NEW YORK 13421

MARK	DATE	DESCRIPTION
REVISIONS		
PROJECT NO:	E42.003.001	
DATE:	12/22/2025	
DRAWN BY:	ASHERMAN	
DESIGNED BY:	ASHERMAN	
CHECKED BY:	Checker	
NO ALTERATION PERMITTED HEREON EXCEPT AS PROVIDED UNDER SECTION 7209 SUBDIVISION 2 OF THE NEW YORK EDUCATION LAW		

**TYPICAL MOUNTING
HEIGHTS AND
ELEVATIONS**

A-250